

J:\Stanley Herzog Foundation\2020.267 Stanley Herzog Foundation\2 Drawings and Specifications\Progress Prints\2020 0810 - Planning Commission Submittal\PACKAGE 2\2020 0814 - Herzog PC2.rvt

Stanley Herzog Foundation

ISSUED FOR:
Planning Commission

Owner
Stanley Herzog Foundation
700 S Riverside Rd
Saint Joseph, MO 64507
Contact:

Architect
GastingerWalker&
817 Wyandotte Street
Kansas City, MO 64115
Contact: Anthony Luca
816.569.0819

Landscape Architect
Hoerr Schaudt Landscape Architects
2100 Central Street, Suite 01C
Kansas City, MO 64108
Contact:

Structural Engineer
PMA Engineering
6717 Shawnee Mission Pkwy #100
Overland Park, KS 66202
Contact:

Civil Engineer
SK Design Group, Inc.
4600 College Blvd. Suite 100
Overland Park, KS 66211
Contact:

MEP Engineer
PKMR Engineers
13300 W 96th Street
Lenexa, KS 66215
Contact:

AV & Acoustics
Branch Pattern
7400 College Boulevard, Suite 150
Overland Park, KS 66210
Contact:

SHEET INDEX

00.00 Cover Sheet

10.01 Overall Site Plan
10.05 Erosion Control Plan
10.11 Site Layout Plan-1
10.12 Site Layout Plan-2
10.21 Public Improvement Plan-1
10.22 Public Improvement Plan-2
10.23 Public Improvement Plan-3

14.01 Planting Plan

40.00 Building Elevations
40.01 Building Elevations

95.02 Specialty Site Lighting Photometric Plan

Main Entry



Courtyard & Trails



Project Summary

18,000 SF New Construction
Construction Type: IIIB Fully Sprinklered

Percent glazing: 39%

Offices
28 Employees

Presentation Hall
150 Seats

Aerial looking SE



Aerial looking NW



GastingerWalker&

Architects | Interior Designers | Construction Managers
817 Wyandotte Kansas City Missouri 64105 816.421.8200 gastingerwalker.com

LANDSCAPE ARCHITECT
HOERR SCHAUDT LANDSCAPE ARCHITECTS
312.492.6501

CIVIL
SK Design Group, Inc.
913.451.1818

STRUCTURAL
PMA Engineering
913.831.1262

MECHANICAL, ELECTRICAL, PLUMBING
PKMR Engineers
913.492.2400

AV & ACOUSTIC
BranchPattern
913.228.3604

LIGHTING DESIGNER
LightWorks, Inc.
816.640.9948

FOOD FACILITY DESIGNER
Santee/Becker Associates, LLC
913.362.1800

Stanley Herzog Foundation

NW 188th Street
Smithville, Missouri 64089

ISSUED FOR:

Planning Commission Pkg 2

08.21.2020

Missouri Certificate of Authority: #ARC000344

Drawn By
Checked By


Author
Checker

Cover Sheet and General
Information

00.00

Project Number: 2020.267

© Copyright 2020

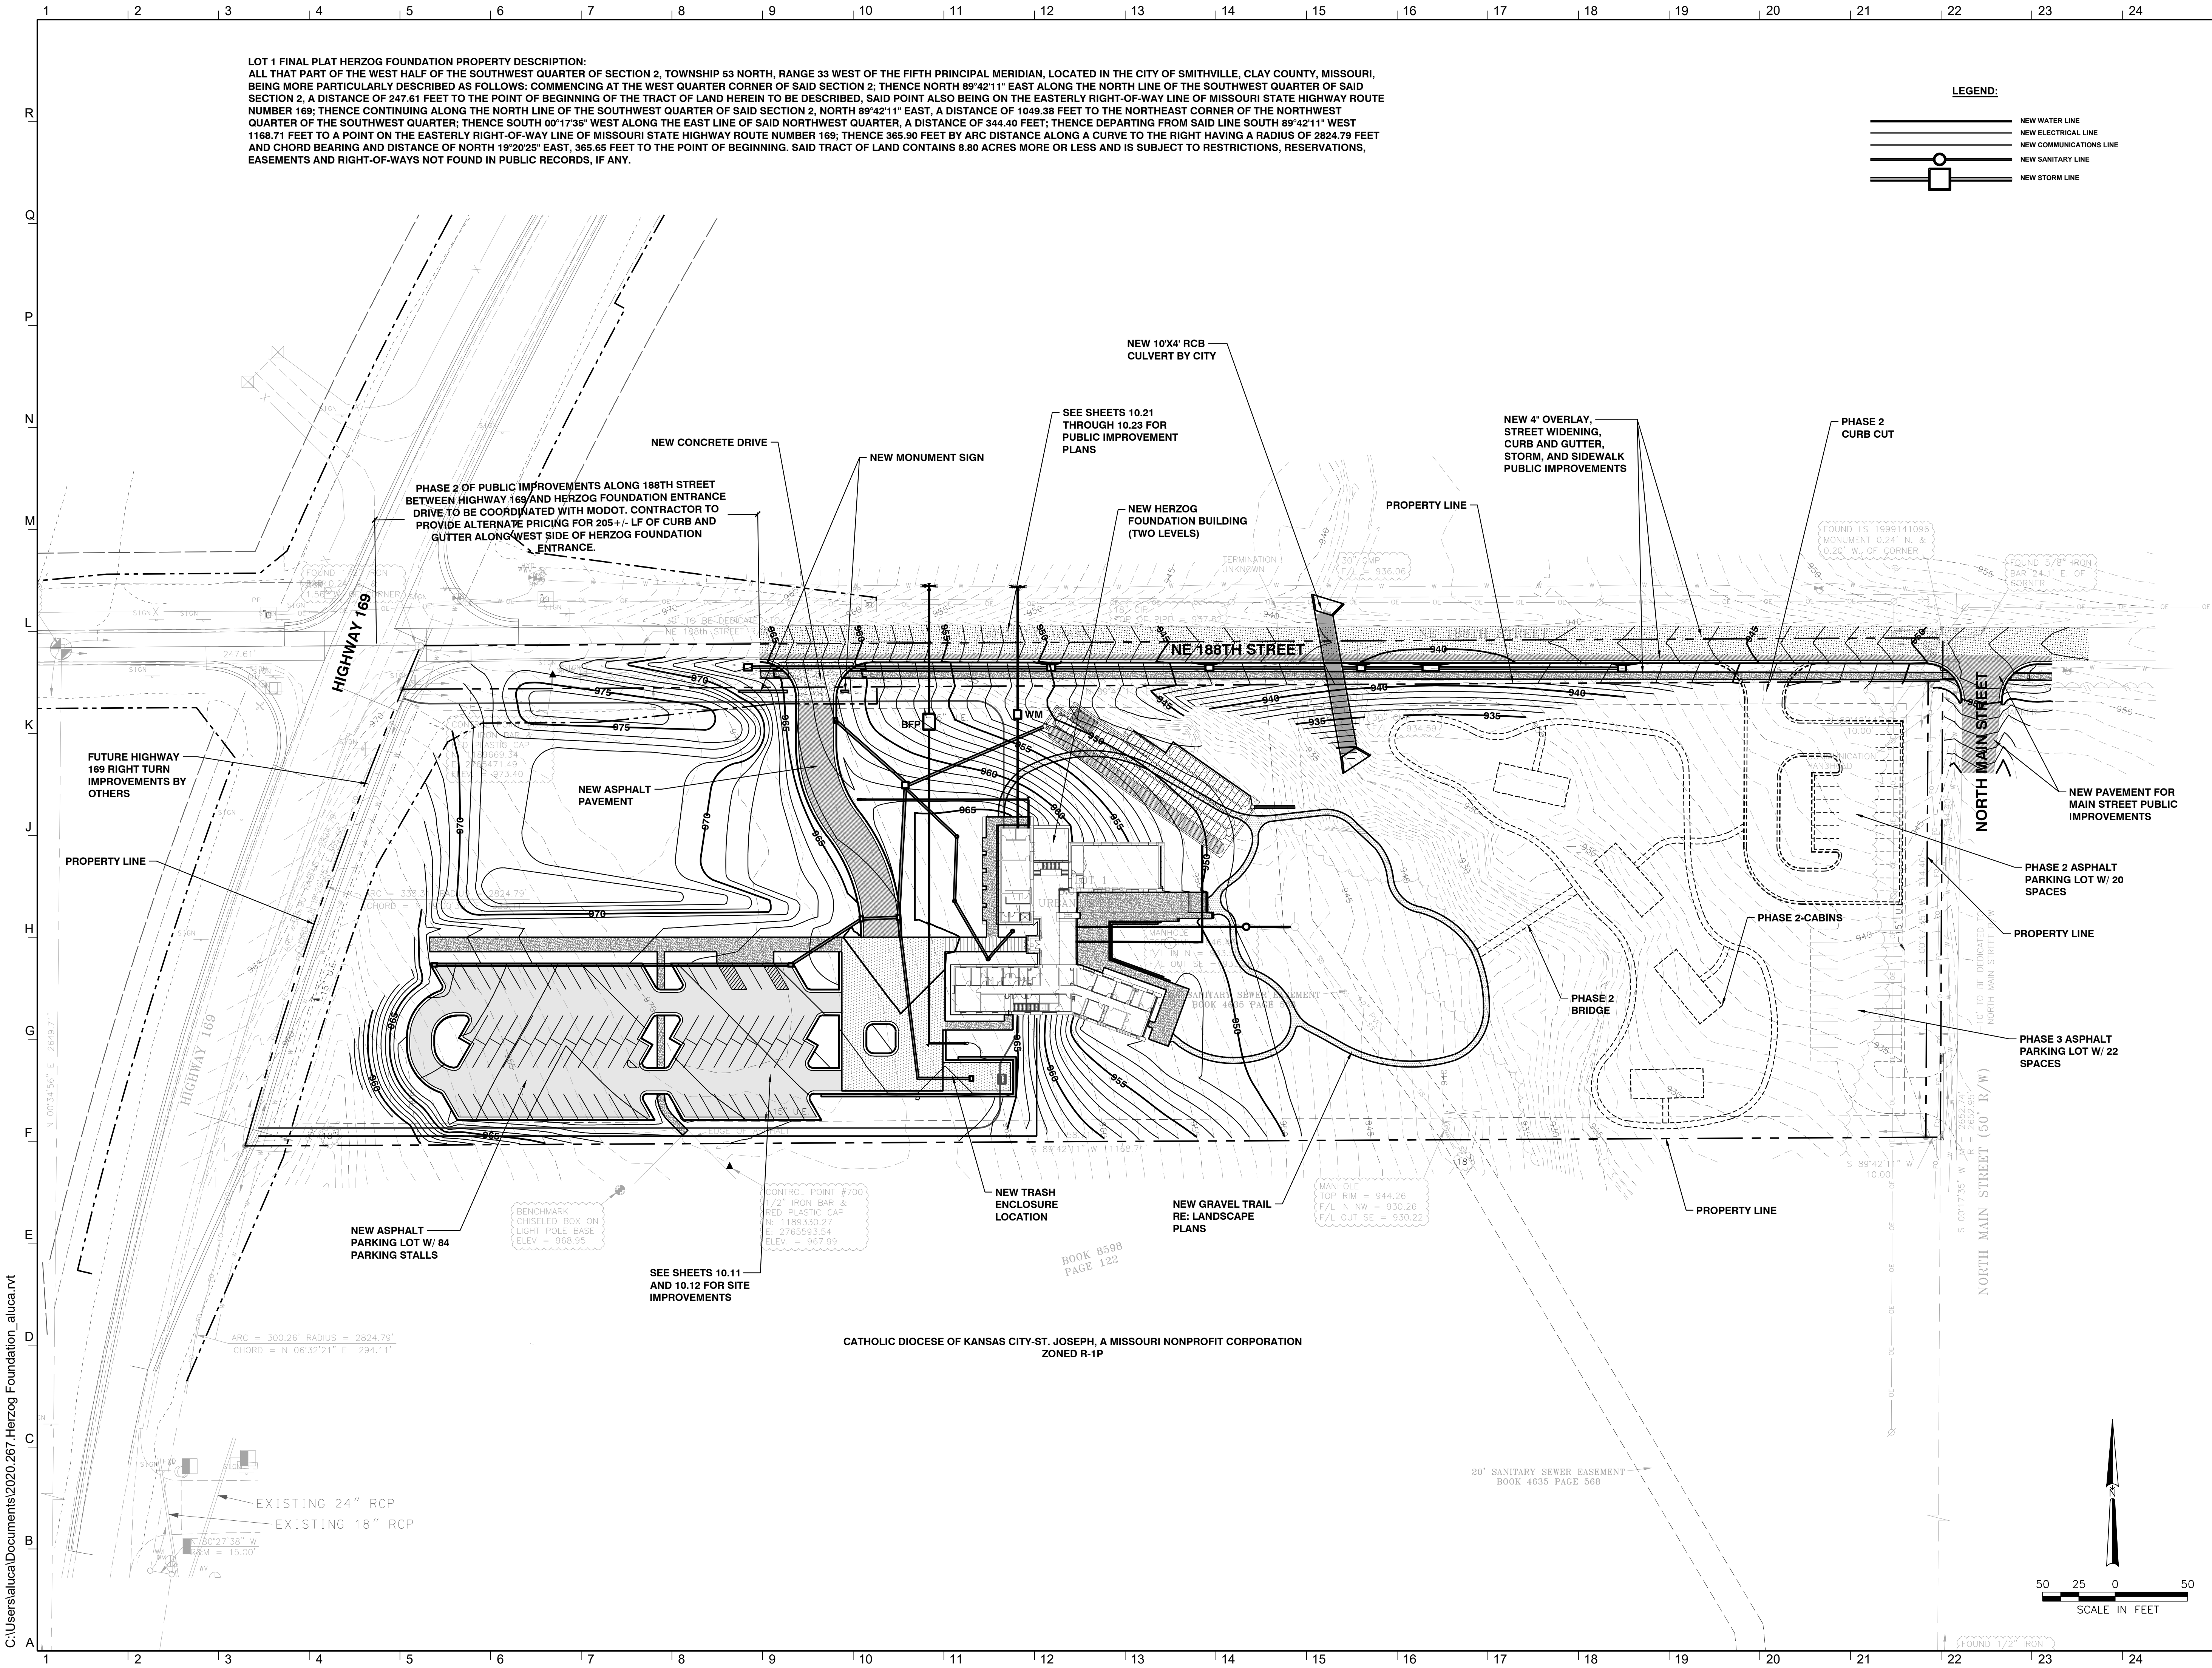

- LANDSCAPE ARCHITECT
HOERR SCHAUDT LANDSCAPE ARCHITECTS
312.492.6501
- CIVIL
SK Design Group, Inc.
913.451.1818
- STRUCTURAL
PMA Engineering
913.831.1262
- MECHANICAL, ELECTRICAL, PLUMBING
PKMR Engineers
913.492.2400
- AV & ACOUSTIC
BranchPattern
913.228.3604
- LIGHTING DESIGNER
LightWorks, Inc.
816.640.9948
- FOOD FACILITY DESIGNER
Santee/Becker Associates, LLC
913.362.1800

Stanley Herzog Foundation

NW 188th Street
Smithville, Missouri 64089


ISSUED FOR:
Planning Commission 09.03.2020

Drawn By Author
Checked By Checker

Overall Site Plan

10.01

Project Number: 2020.267 © Copyright 2020

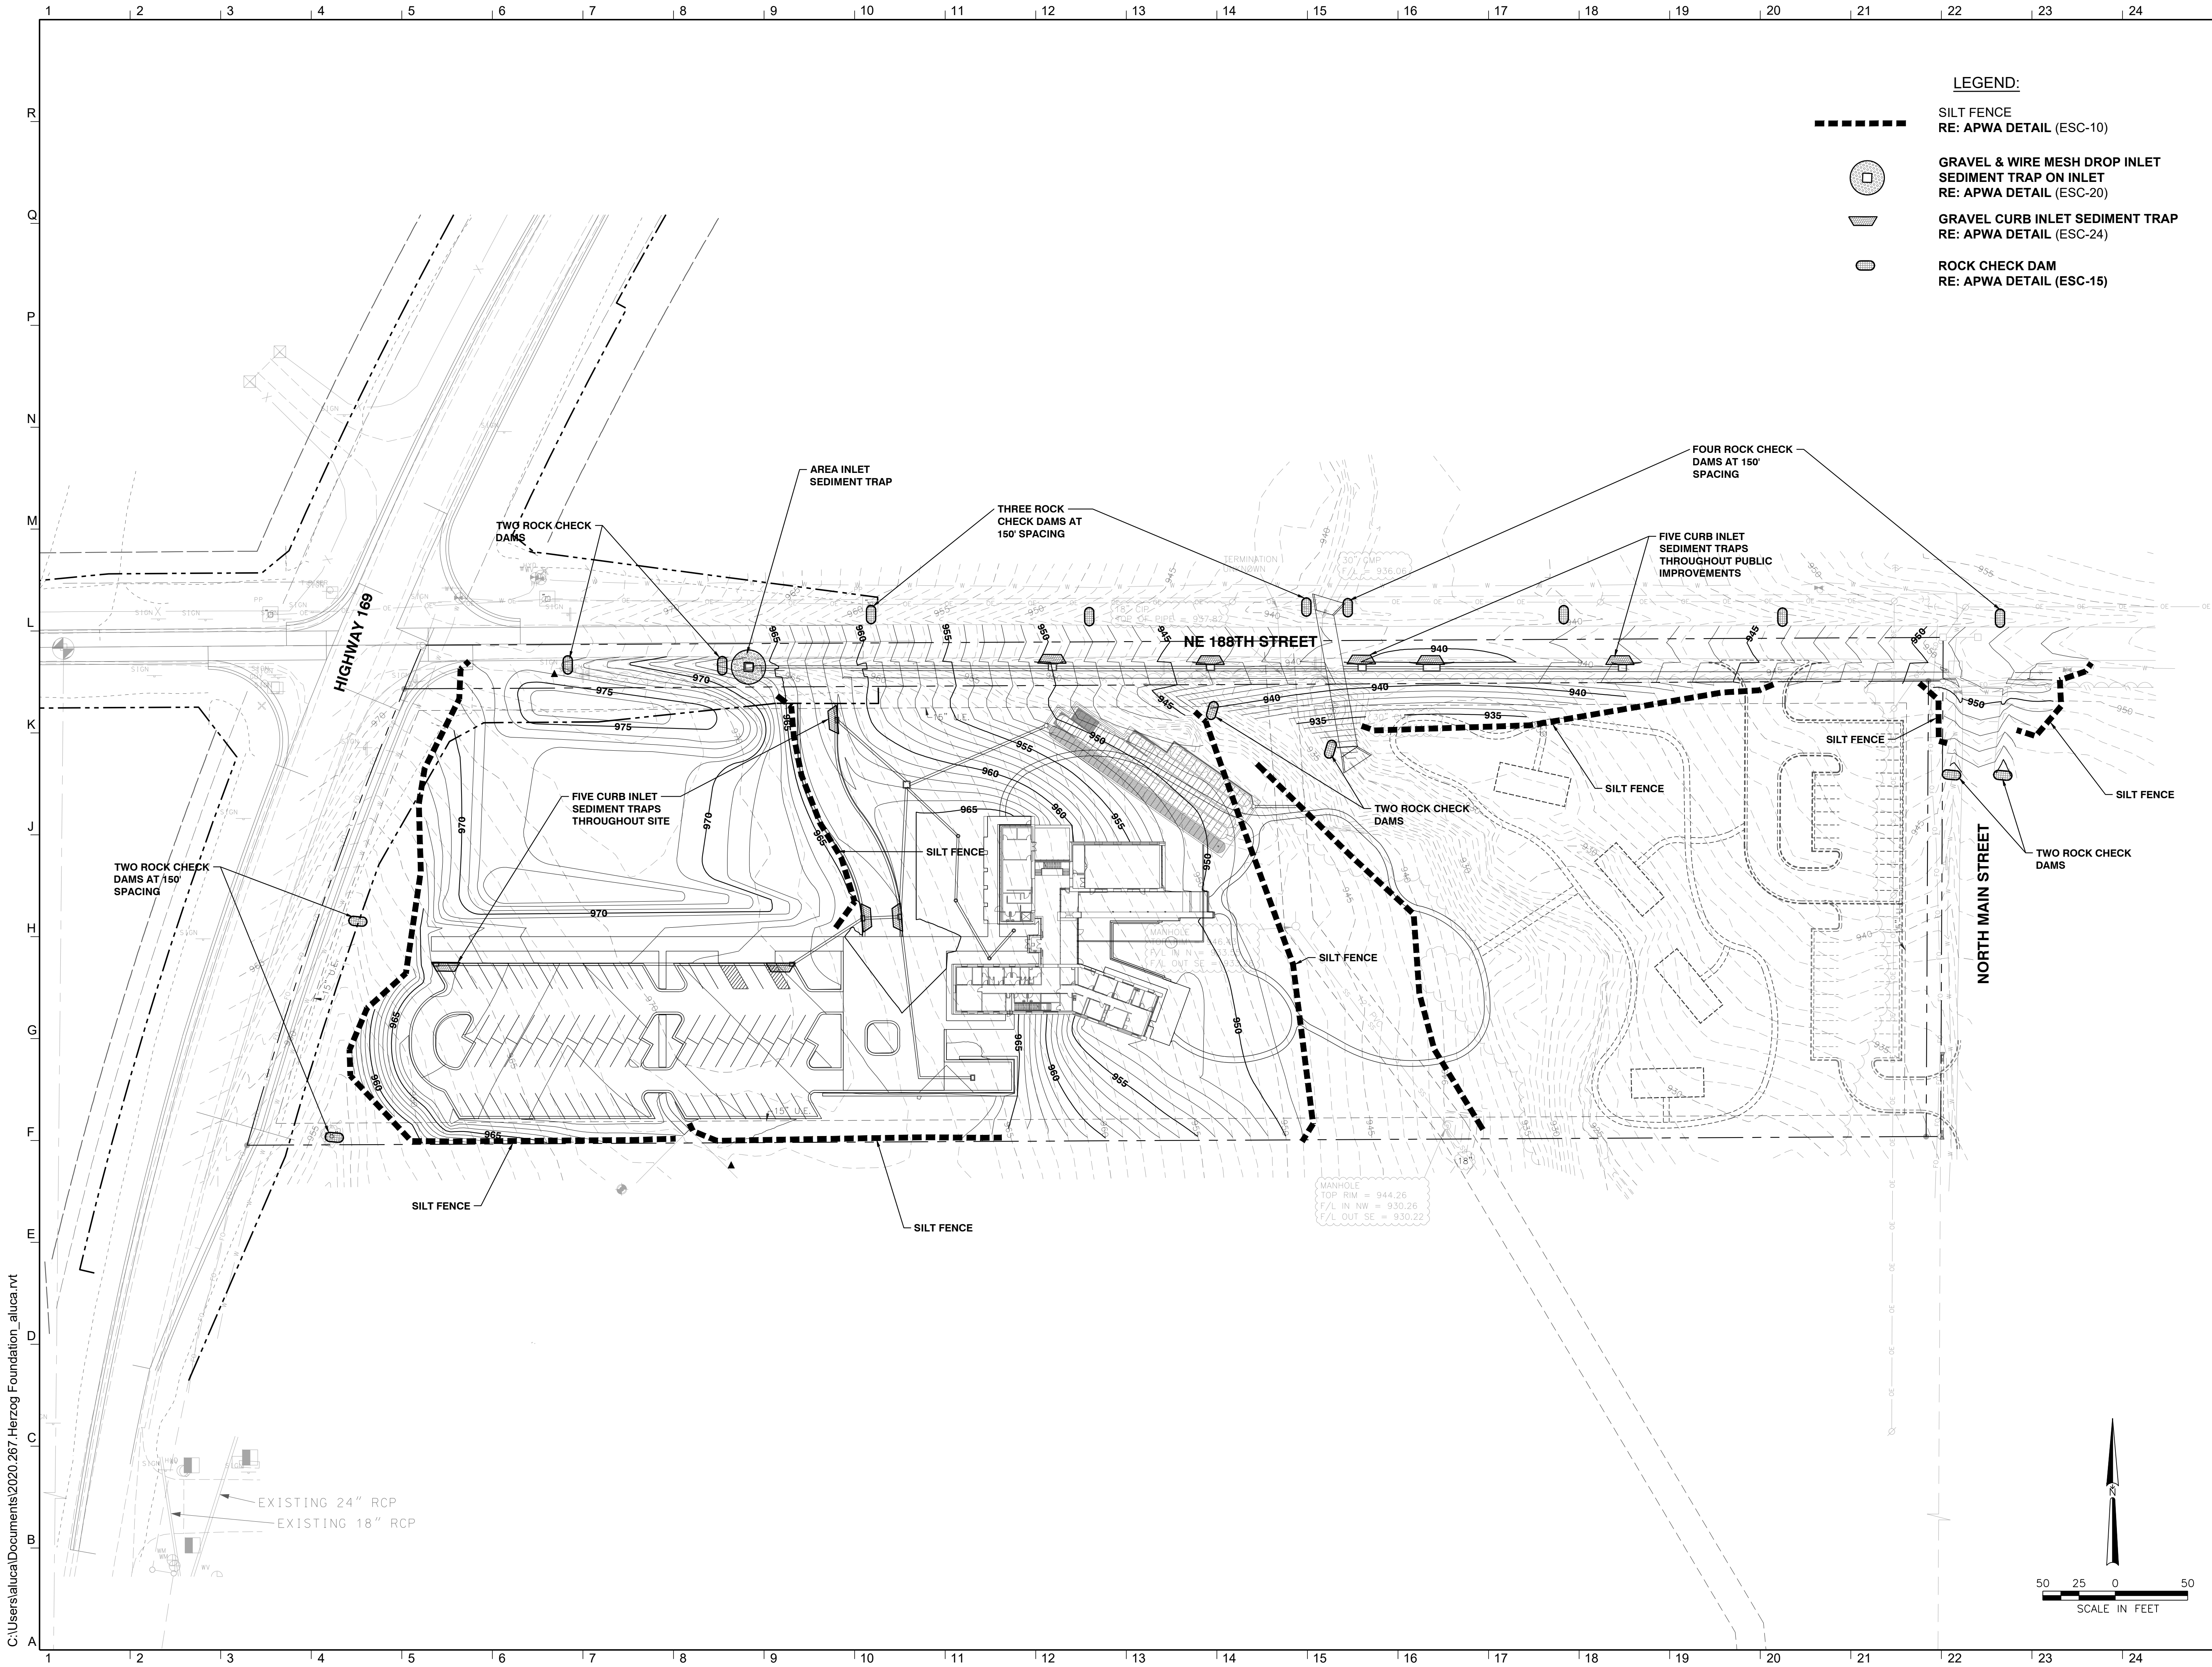

LANDSCAPE ARCHITECT
HOERR SCHAUDT LANDSCAPE ARCHITECTS
312.492.6501

CIVIL
SK Design Group, Inc
913.451.1818

STRUCTURAL
PMA Engineering
913.831.1262

MECHANICAL, ELECTRICAL, PLUMBING
PKMR Engineers
913.492.2400

AV & ACOUSTIC
BranchPattern
913.228.3604

LIGHTING DESIGNER
LightWorks, Inc.
816.640.9948

FOOD FACILITY DESIGNER
Santee/Becker Associates, LLC
913.362.1800

Stanley Herzog
Foundation


NW 188th Street
Smithville, Missouri 64089

ISSUED FOR:
Planning Commission 09.03.2020

Drawn By
Checked By

Author
Checker

EROSION CONTROL PLAN

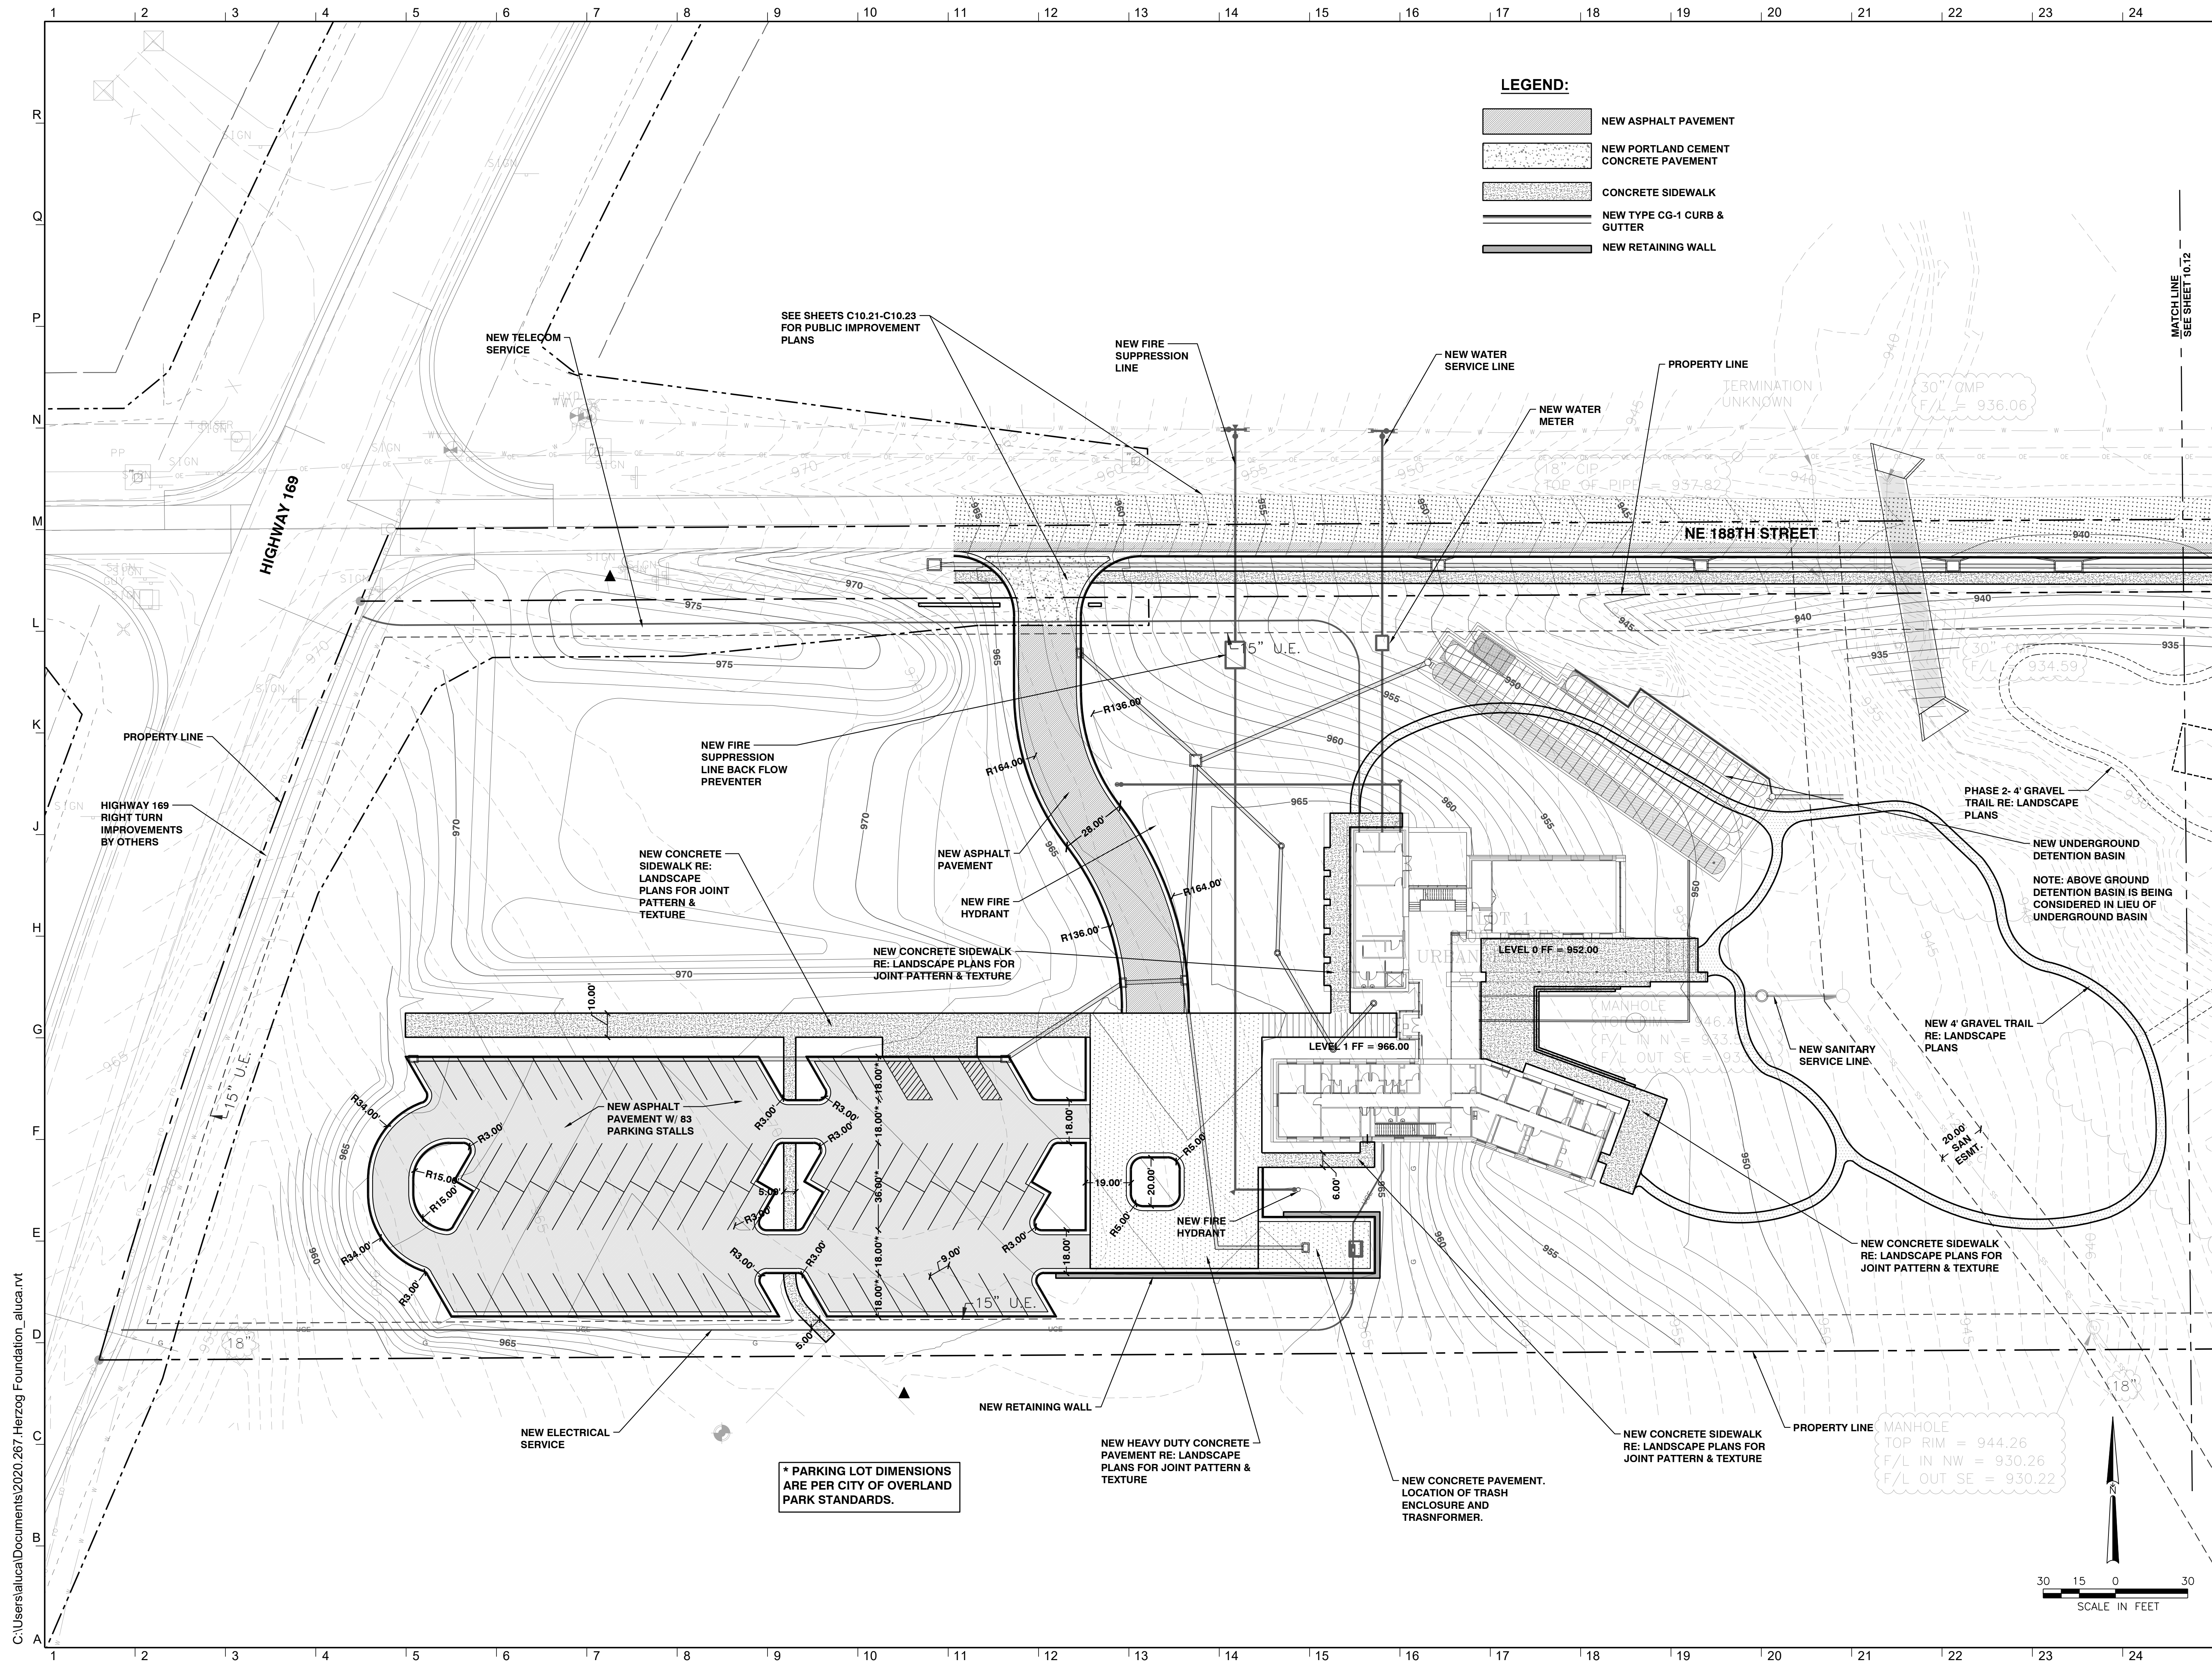

GastingerWalker &

Architects | Interior Designers | Construction Managers
817 Wyandotte Kansas City Missouri 64105 816.421.8200 gastingerwalker.com

LANDSCAPE ARCHITECT
HOERR SCHAUDT LANDSCAPE ARCHITECTS
312.492.6501

CIVIL
SK Design Group, Inc
913.451.1818

STRUCTURAL
PMA Engineering
913.831.1262

MECHANICAL, ELECTRICAL, PLUMBING
PKMR Engineers
913.492.2400

AV & ACOUSTIC
BranchPattern
913.228.3604

LIGHTING DESIGNER
LightWorks, Inc.
816.640.9948

FOOD FACILITY DESIGNER
Santee/Becker Associates, LLC
913.362.1800

Stanley Herzog
Foundation

NW 188th Street
Smithville, Missouri 64089

ISSUED FOR:


Planning Commission 09.03.2020

Drawn By	Author
Checked By	Checker

SITE LAYOUT PLAN - 1

10.11

Project Number: 2020.267 © Copyright 2021

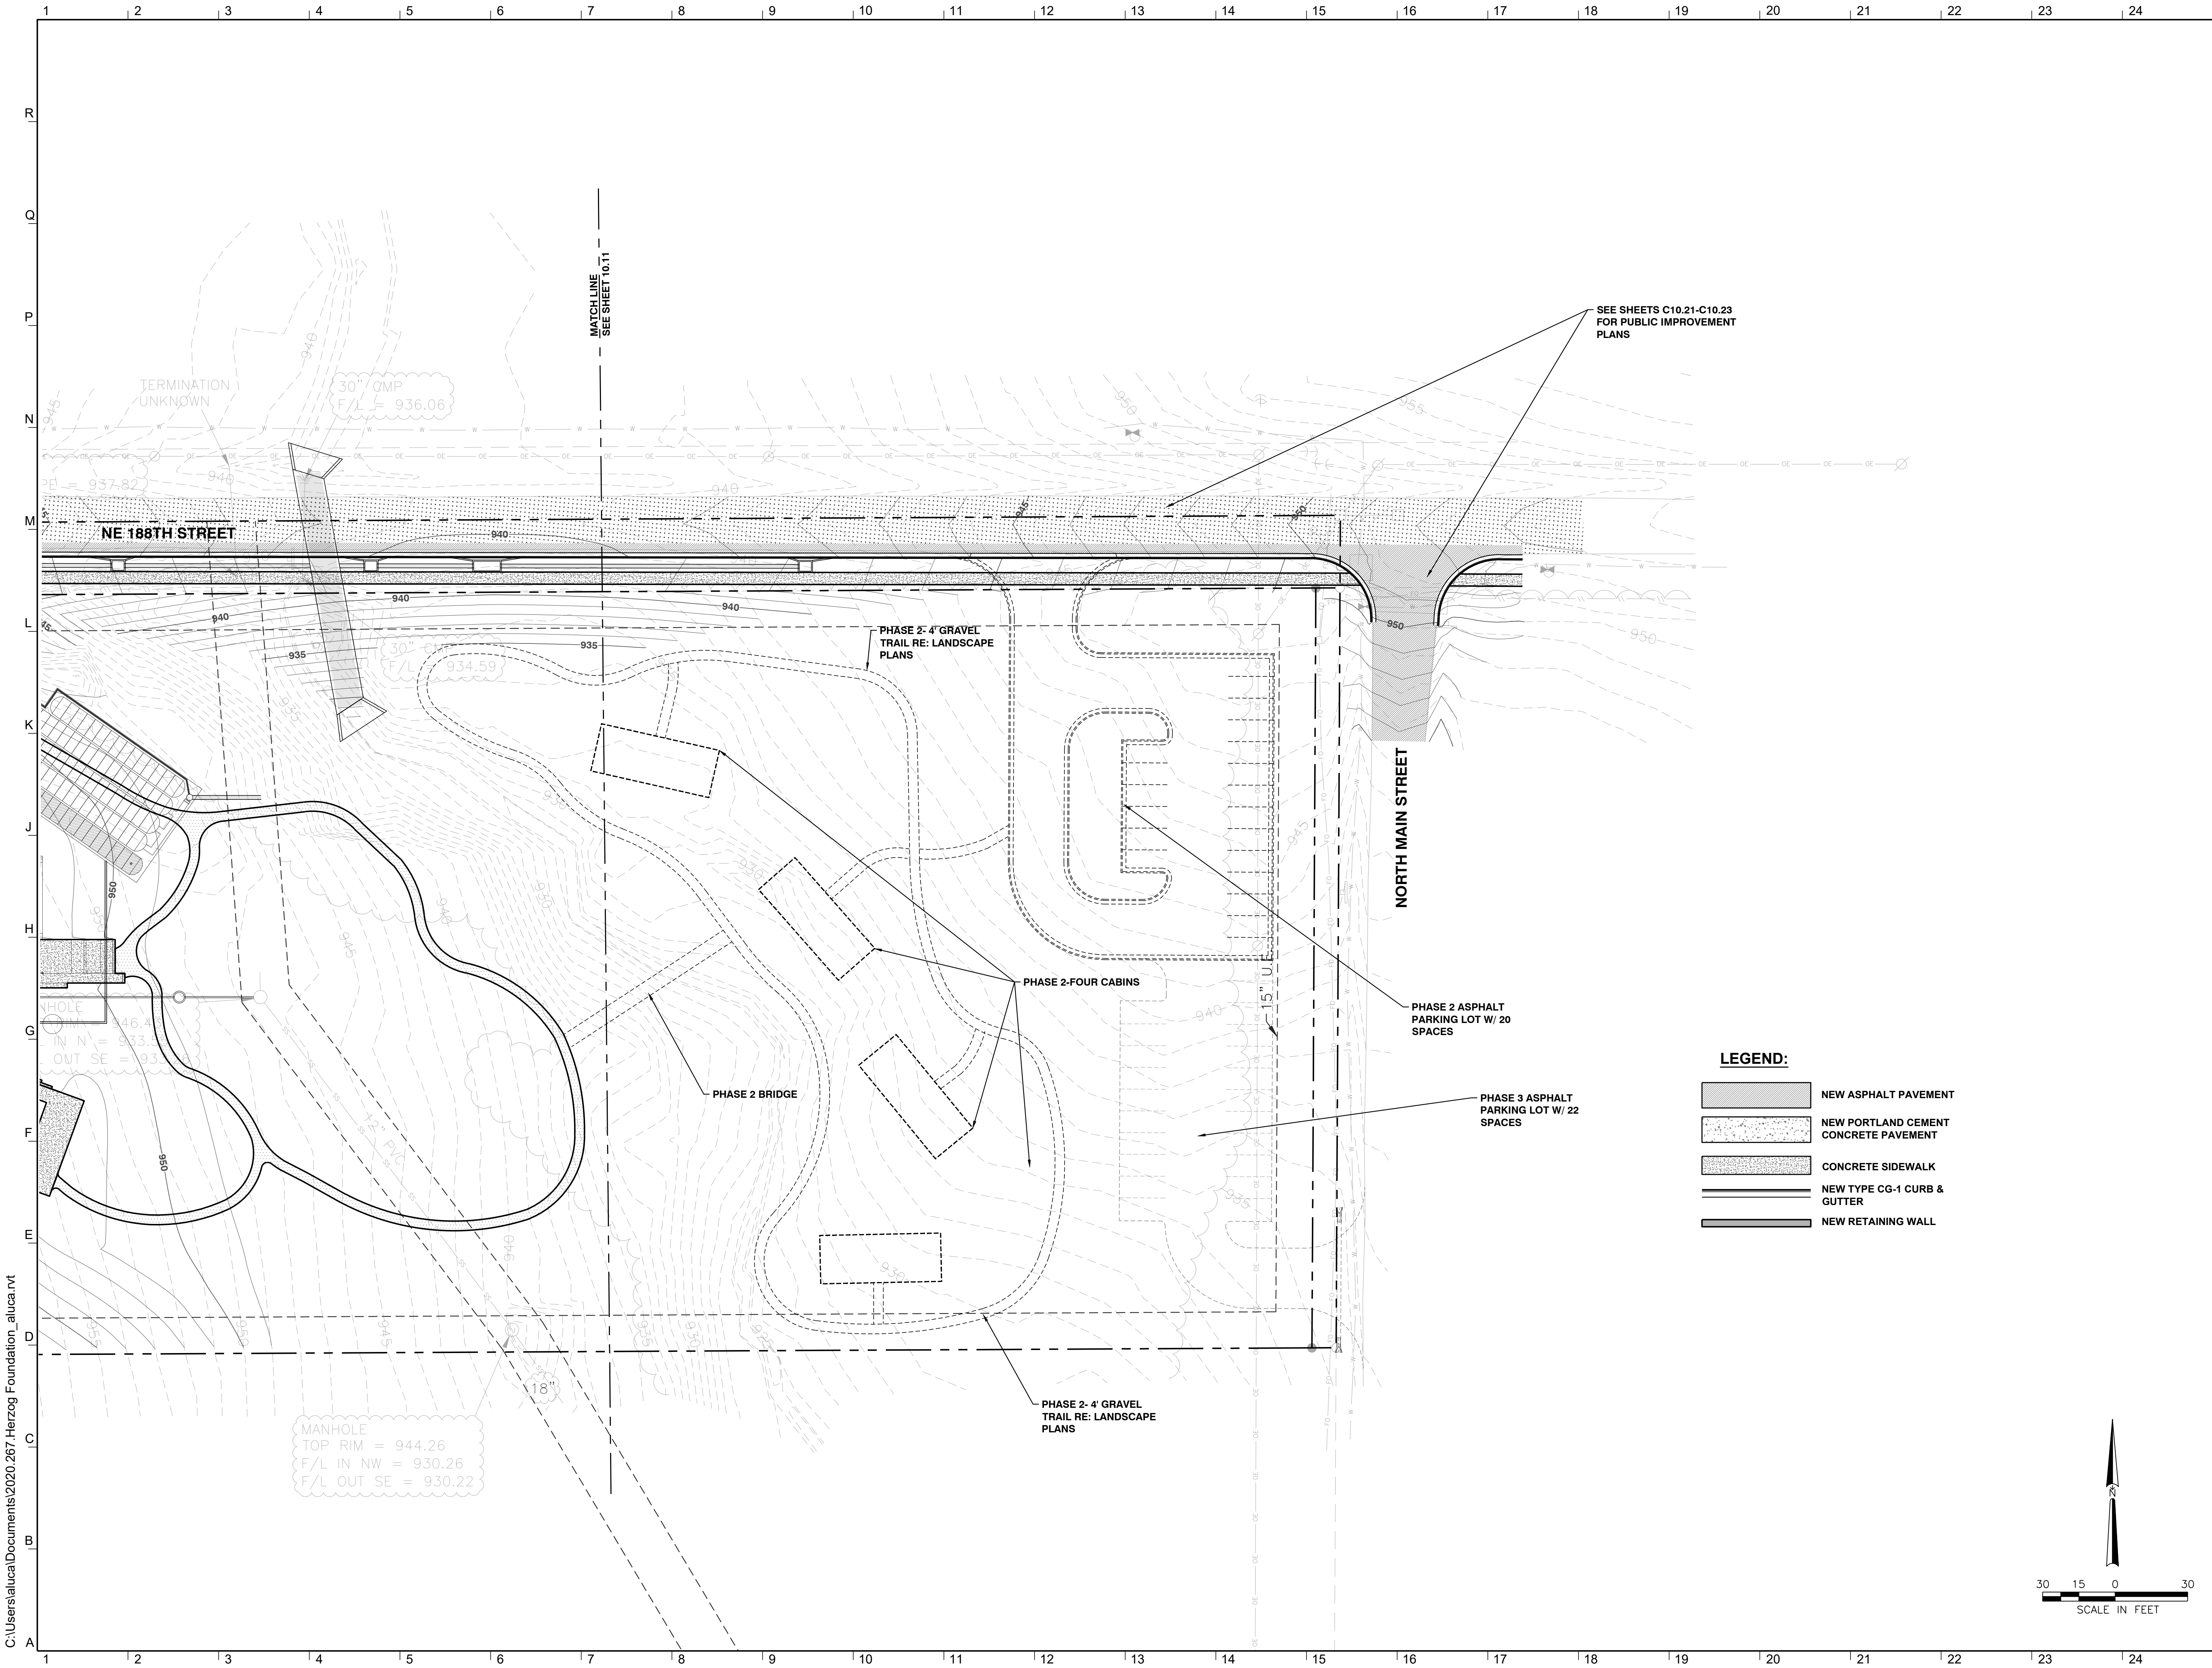

LANDSCAPE ARCHITECT
HOERR SCHAUDT LANDSCAPE ARCHITECTS
312.492.6501

CIVIL
SK Design Group, Inc.
913.451.1818

STRUCTURAL
PMA Engineering
913.831.1262

MECHANICAL, ELECTRICAL, PLUMBING
PKMR Engineers
913.492.2400

AV & ACOUSTIC
BranchPattern
913.228.3604

LIGHTING DESIGNER
LightWorks, Inc.
816.640.9948

FOOD FACILITY DESIGNER
Santee/Becker Associates, LLC
913.362.1800

Stanley Herzog
Foundation

NW 188th Street
Smithville, Missouri 64089

ISSUED FOR:

Planning Commission 09.03.2020



Drawn By _____ Author
Checked By _____ Checker

SITE LAYOUT PLAN - 2

10.12

Project Number: 2020.267 © Copyright 2020

C:\Users\aluca\Documents\2020.267 Herzog Foundation_aluca.rvt

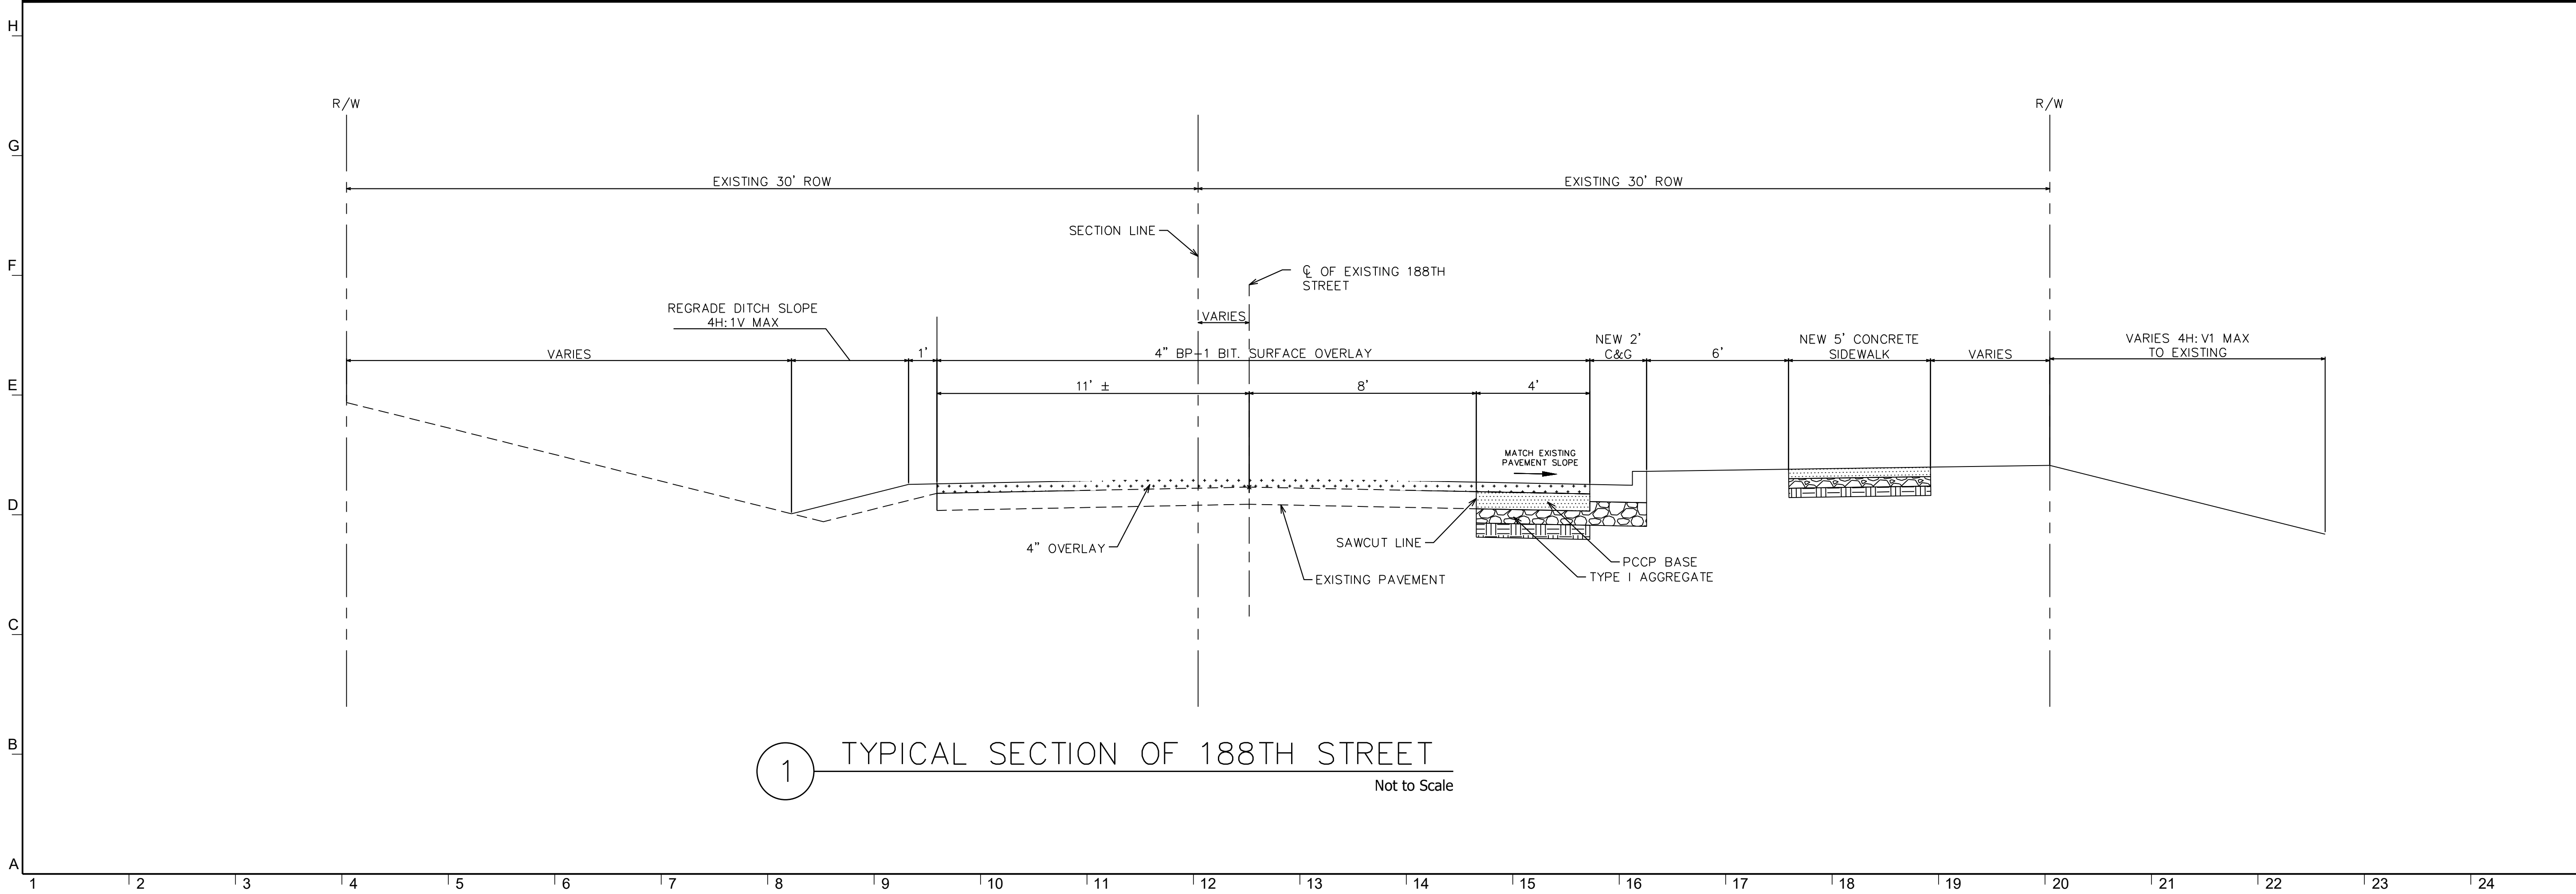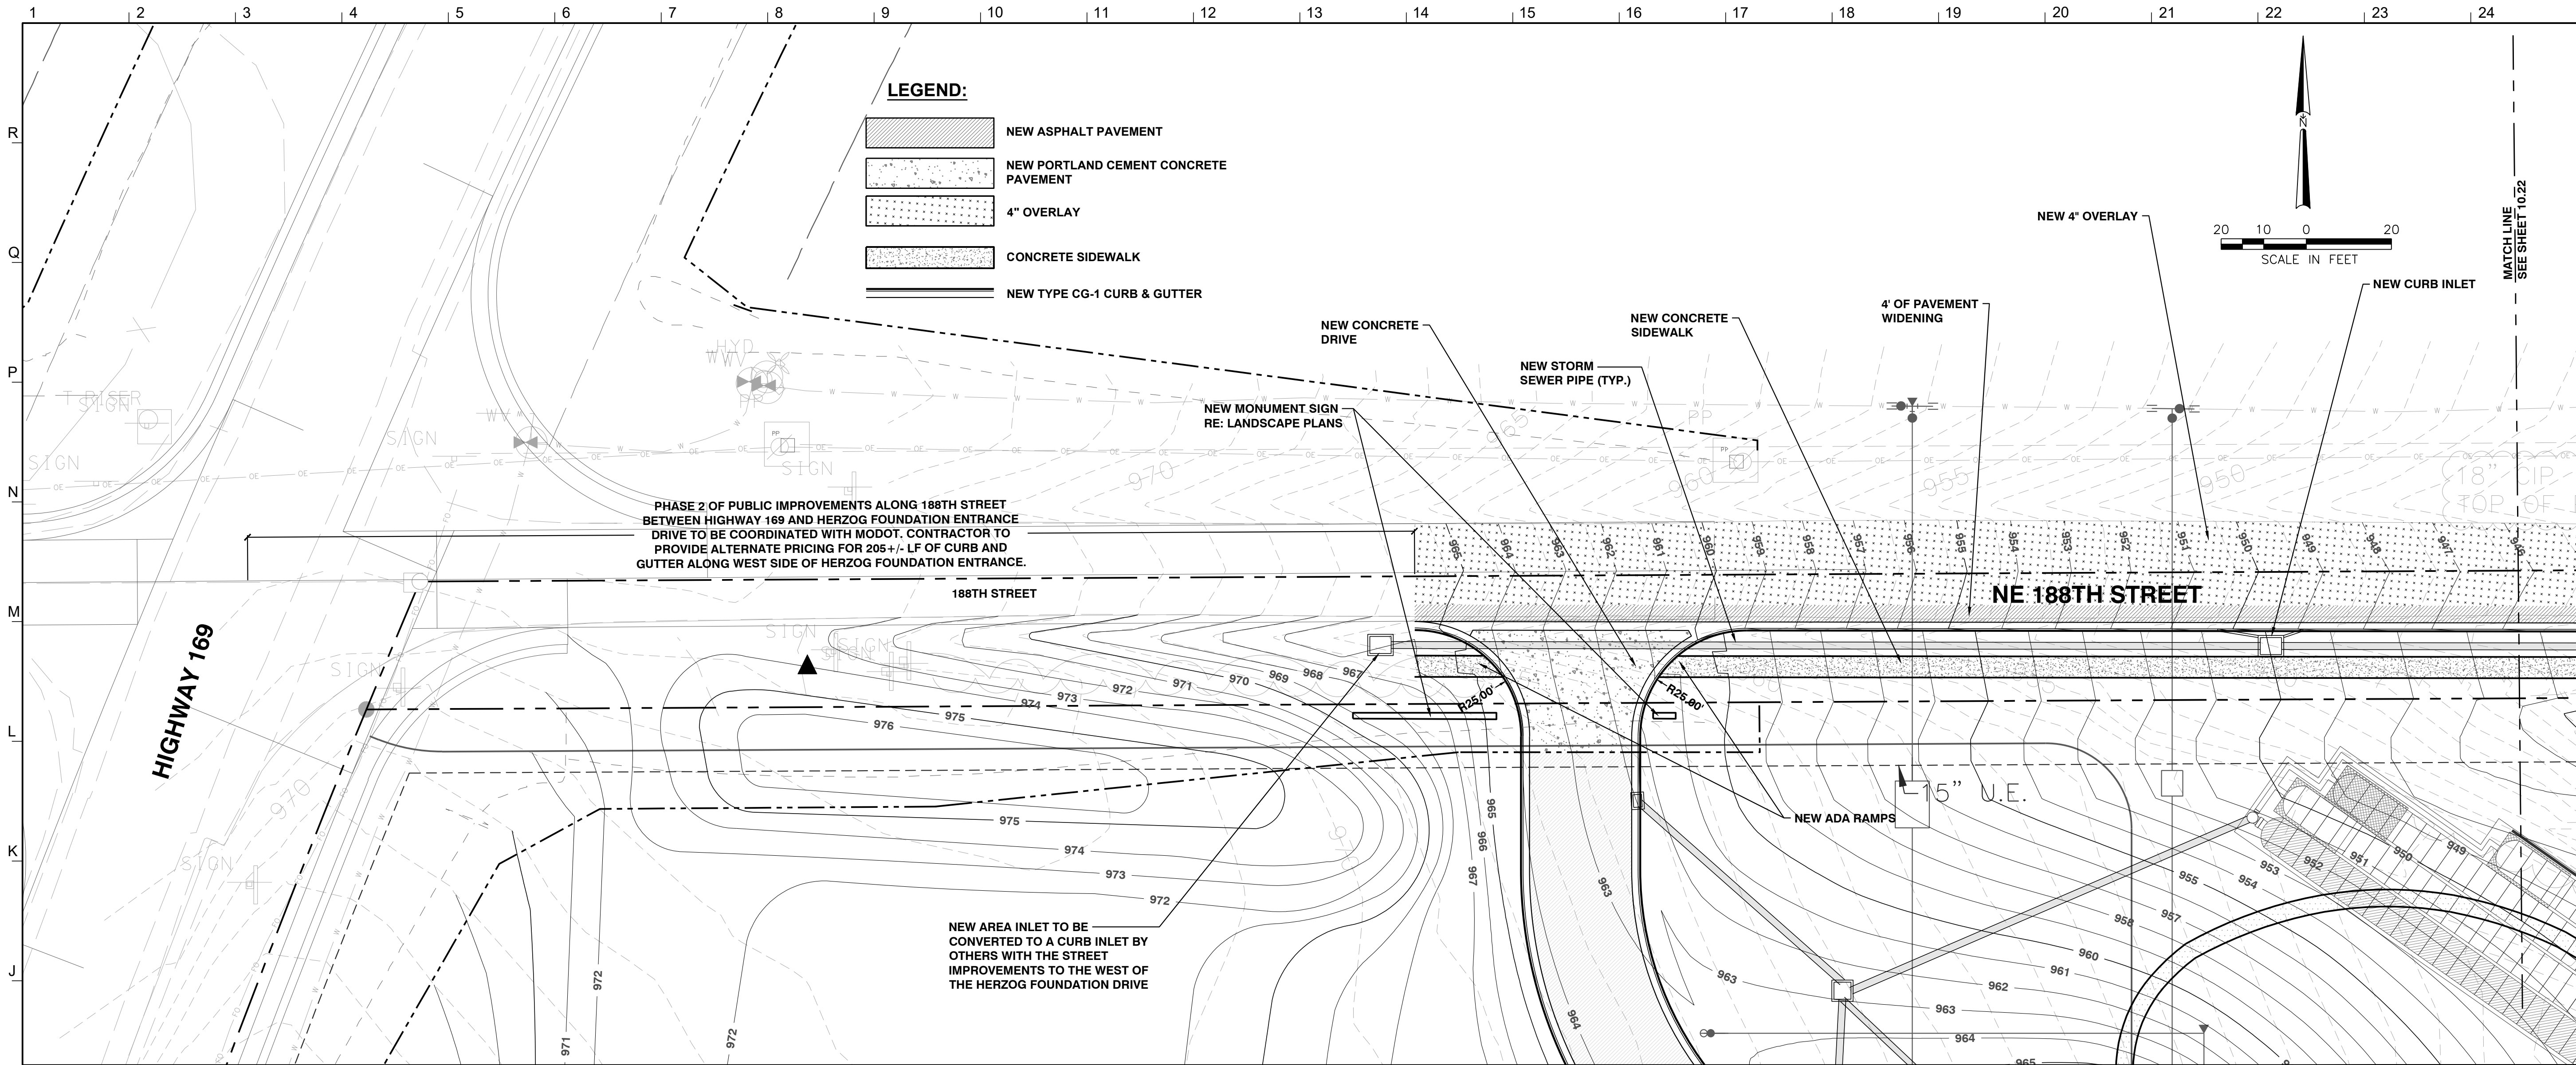

1 TYPICAL SECTION OF 188TH STREET

Not to Scale

- LANDSCAPE ARCHITECT
HOERR SCHAUDT LANDSCAPE ARCHITECTS
312.492.6501
- CIVIL
SK Design Group, Inc.
913.451.1818
- STRUCTURAL
PMA Engineering
913.831.1262
- MECHANICAL, ELECTRICAL, PLUMBING
PKMR Engineers
913.492.2400
- AV & ACOUSTIC
BranchPattern
913.228.3604
- LIGHTING DESIGNER
LightWorks, Inc.
816.640.9948
- FOOD FACILITY DESIGNER
Santee/Becker Associates, LLC
913.362.1800

Stanley Herzog Foundation


NW 188th Street
Smithville, Missouri 64089

ISSUED FOR:
Planning Commission 09.03.2020

Drawn By Author
Checked By Checker

Public Improvement Plan - 1

C:\Users\aluca\Documents\2020.267 Herzog Foundation_aluca.rvt

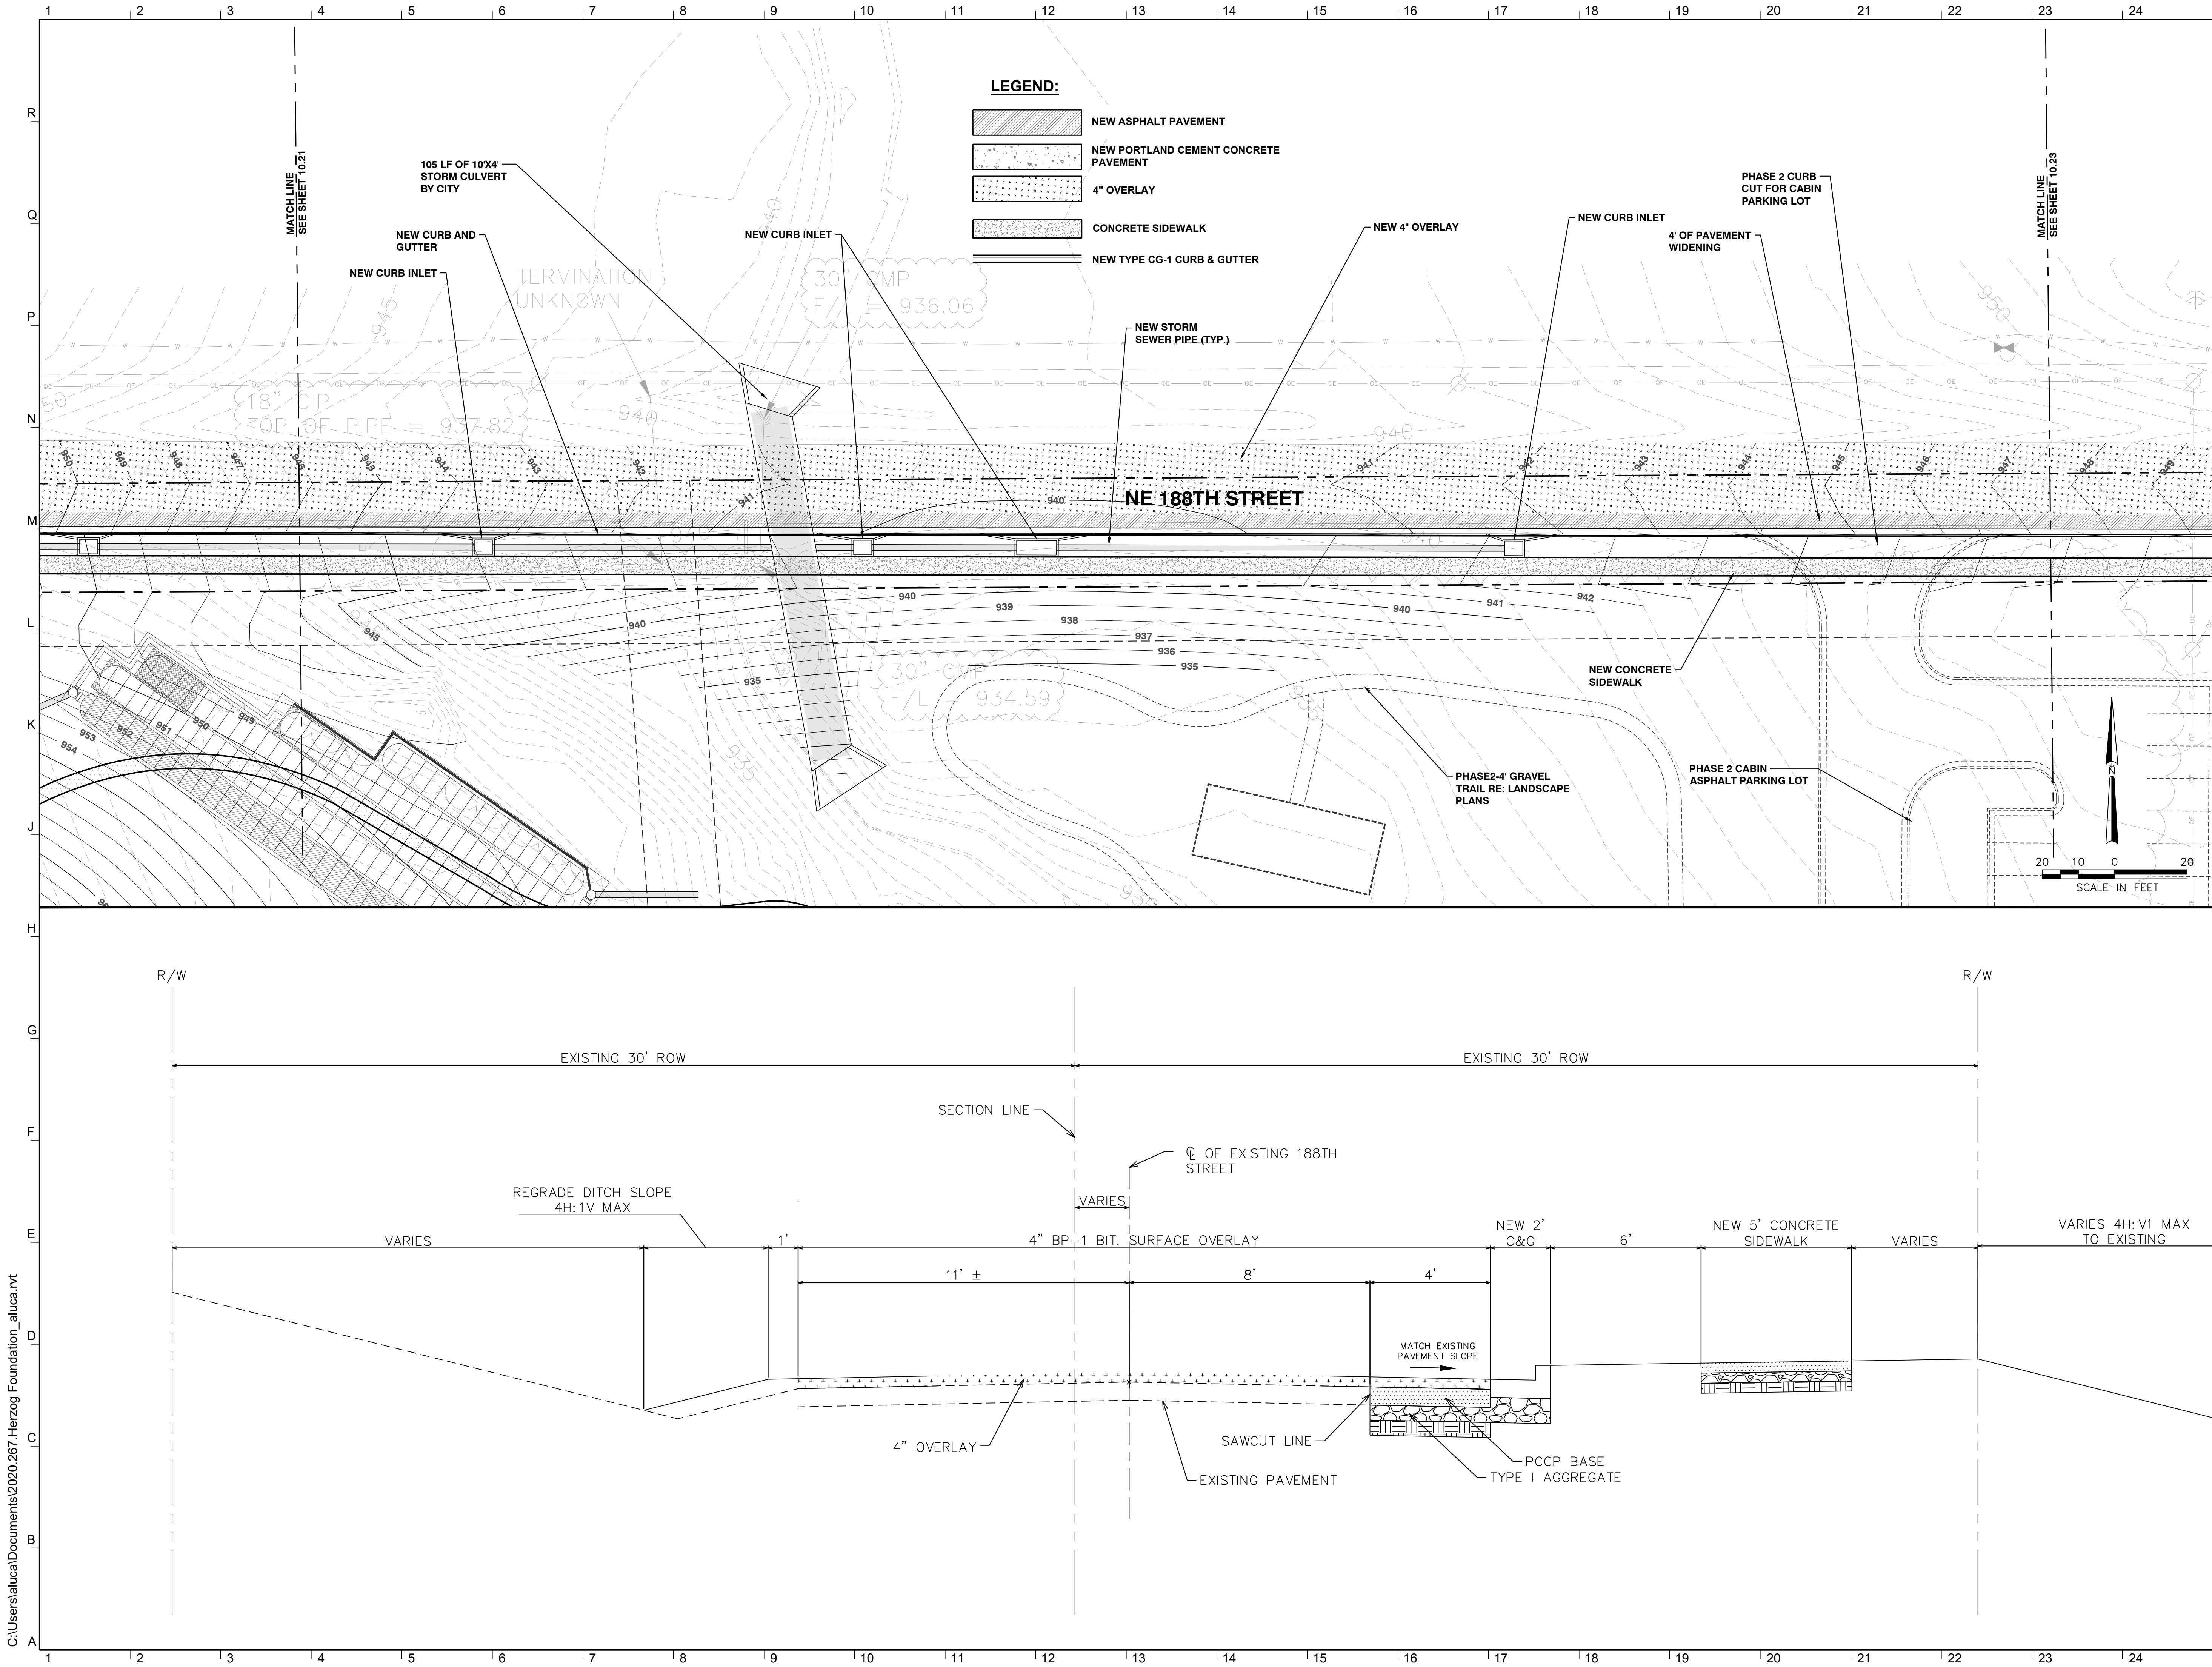

GastingerWalker &

Architects | Interior Designers | Construction Managers
817 WYandotte | Kansas City Missouri 64105 | 816.421.8200 | gastingerwalker.com

LANDSCAPE ARCHITECT
HOERR SCHAUDT LANDSCAPE ARCHITECTS
312.492.6501

CIVIL
SK Design Group, Inc.
913.451.1818

STRUCTURAL
PMA Engineering
913.831.1262

MECHANICAL, ELECTRICAL, PLUMBING
PKMR Engineers
913.492.2400

AV & ACOUSTIC
BranchPattern
913.228.3604

LIGHTING DESIGNER
LightWorks, Inc.
816.640.9948

FOOD FACILITY DESIGNER
Santee/Becker Associates, LLC
913.362.1800

Stanley Herzog Foundation

NW 188th Street
Smithville, Missouri 64089

ISSUED FOR:
Planning Commission 09.03.2020


Drawn By
Checked By

Author
Checker

Public Improvement Plan - 2

10.22

Project Number: 2020.267 © Copyright 2020

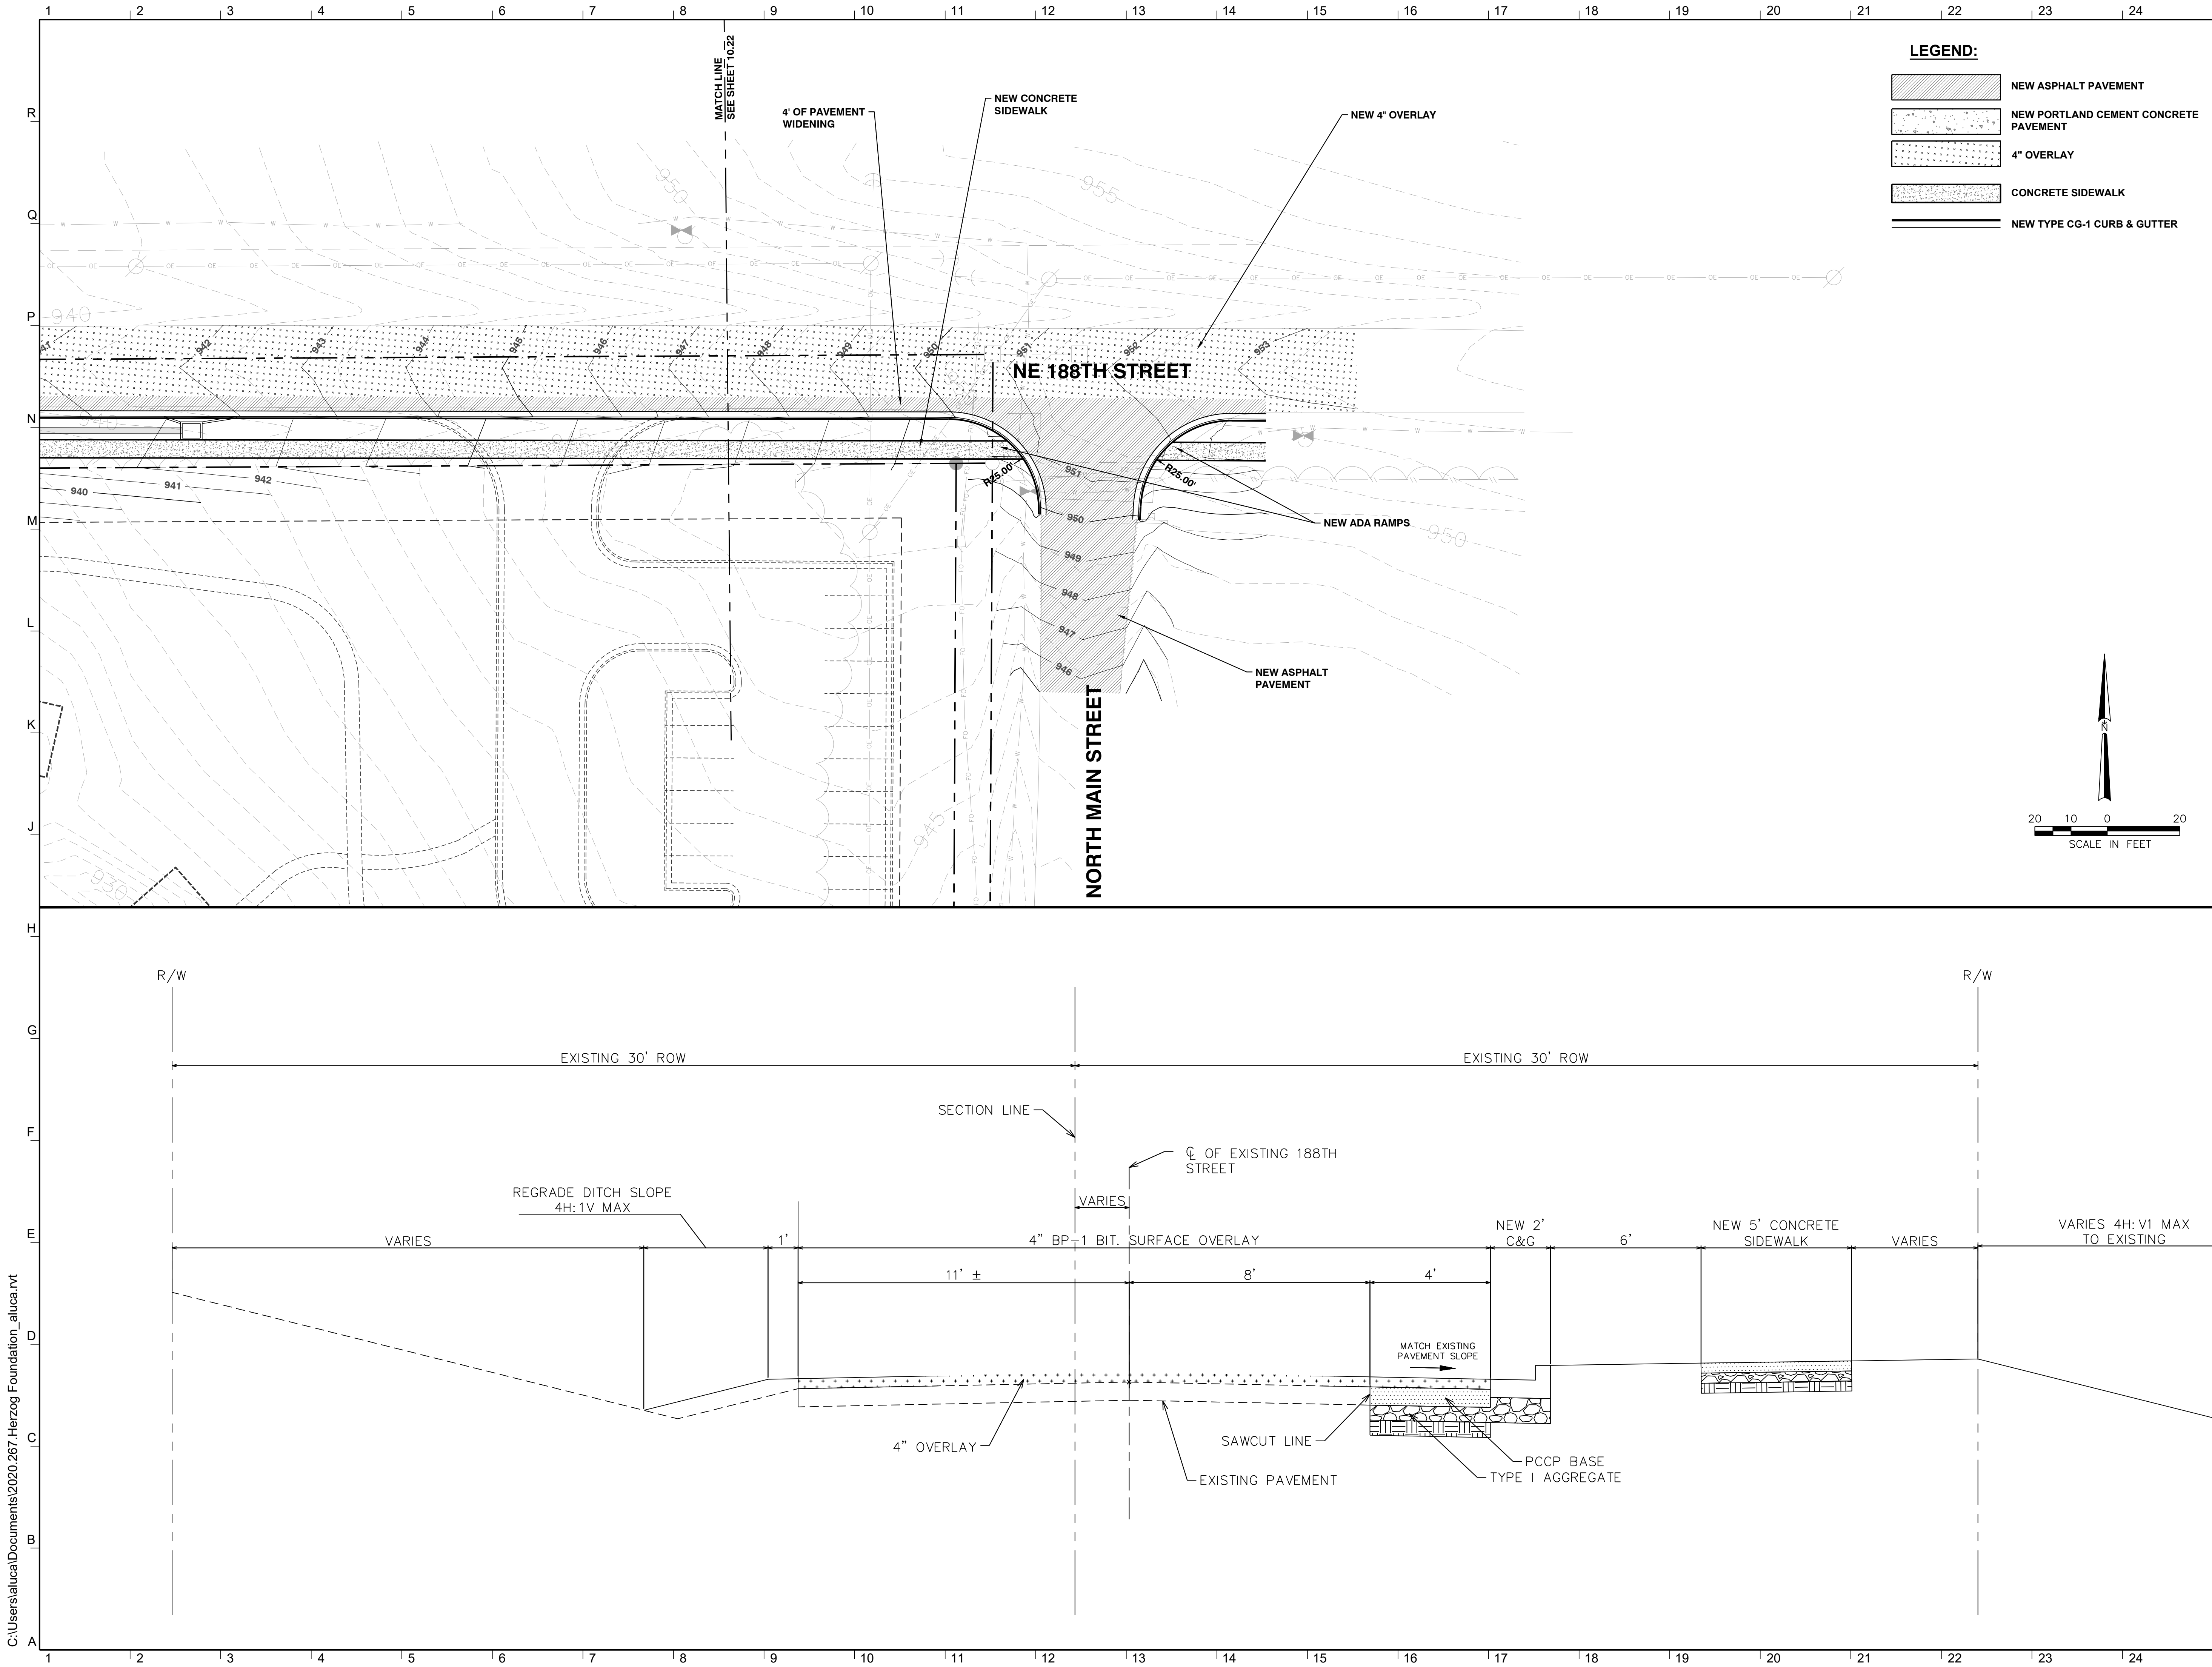

LANDSCAPE ARCHITECT
HOERR SCHAUDT LANDSCAPE ARCHITECTS
312.492.6501

CIVIL
SK Design Group, Inc.
913.451.1818

STRUCTURAL
PMA Engineering
913.831.1262

MECHANICAL, ELECTRICAL, PLUMBING
PKMR Engineers
913.492.2400

AV & ACOUSTIC
BranchPattern
913.228.3604

LIGHTING DESIGNER
LightWorks, Inc.
816.640.9948

FOOD FACILITY DESIGNER
Santee/Becker Associates, LLC
913.362.1800

Stanley Herzog Foundation

NW 188th Street
Smithville, Missouri 64089

ISSUED FOR:


Planning Commission 09.03.2020

Drawn By Author
Checked By Checker

Public Improvement Plan - 3

10.23

Project Number: 2020.267 © Copyright 2020

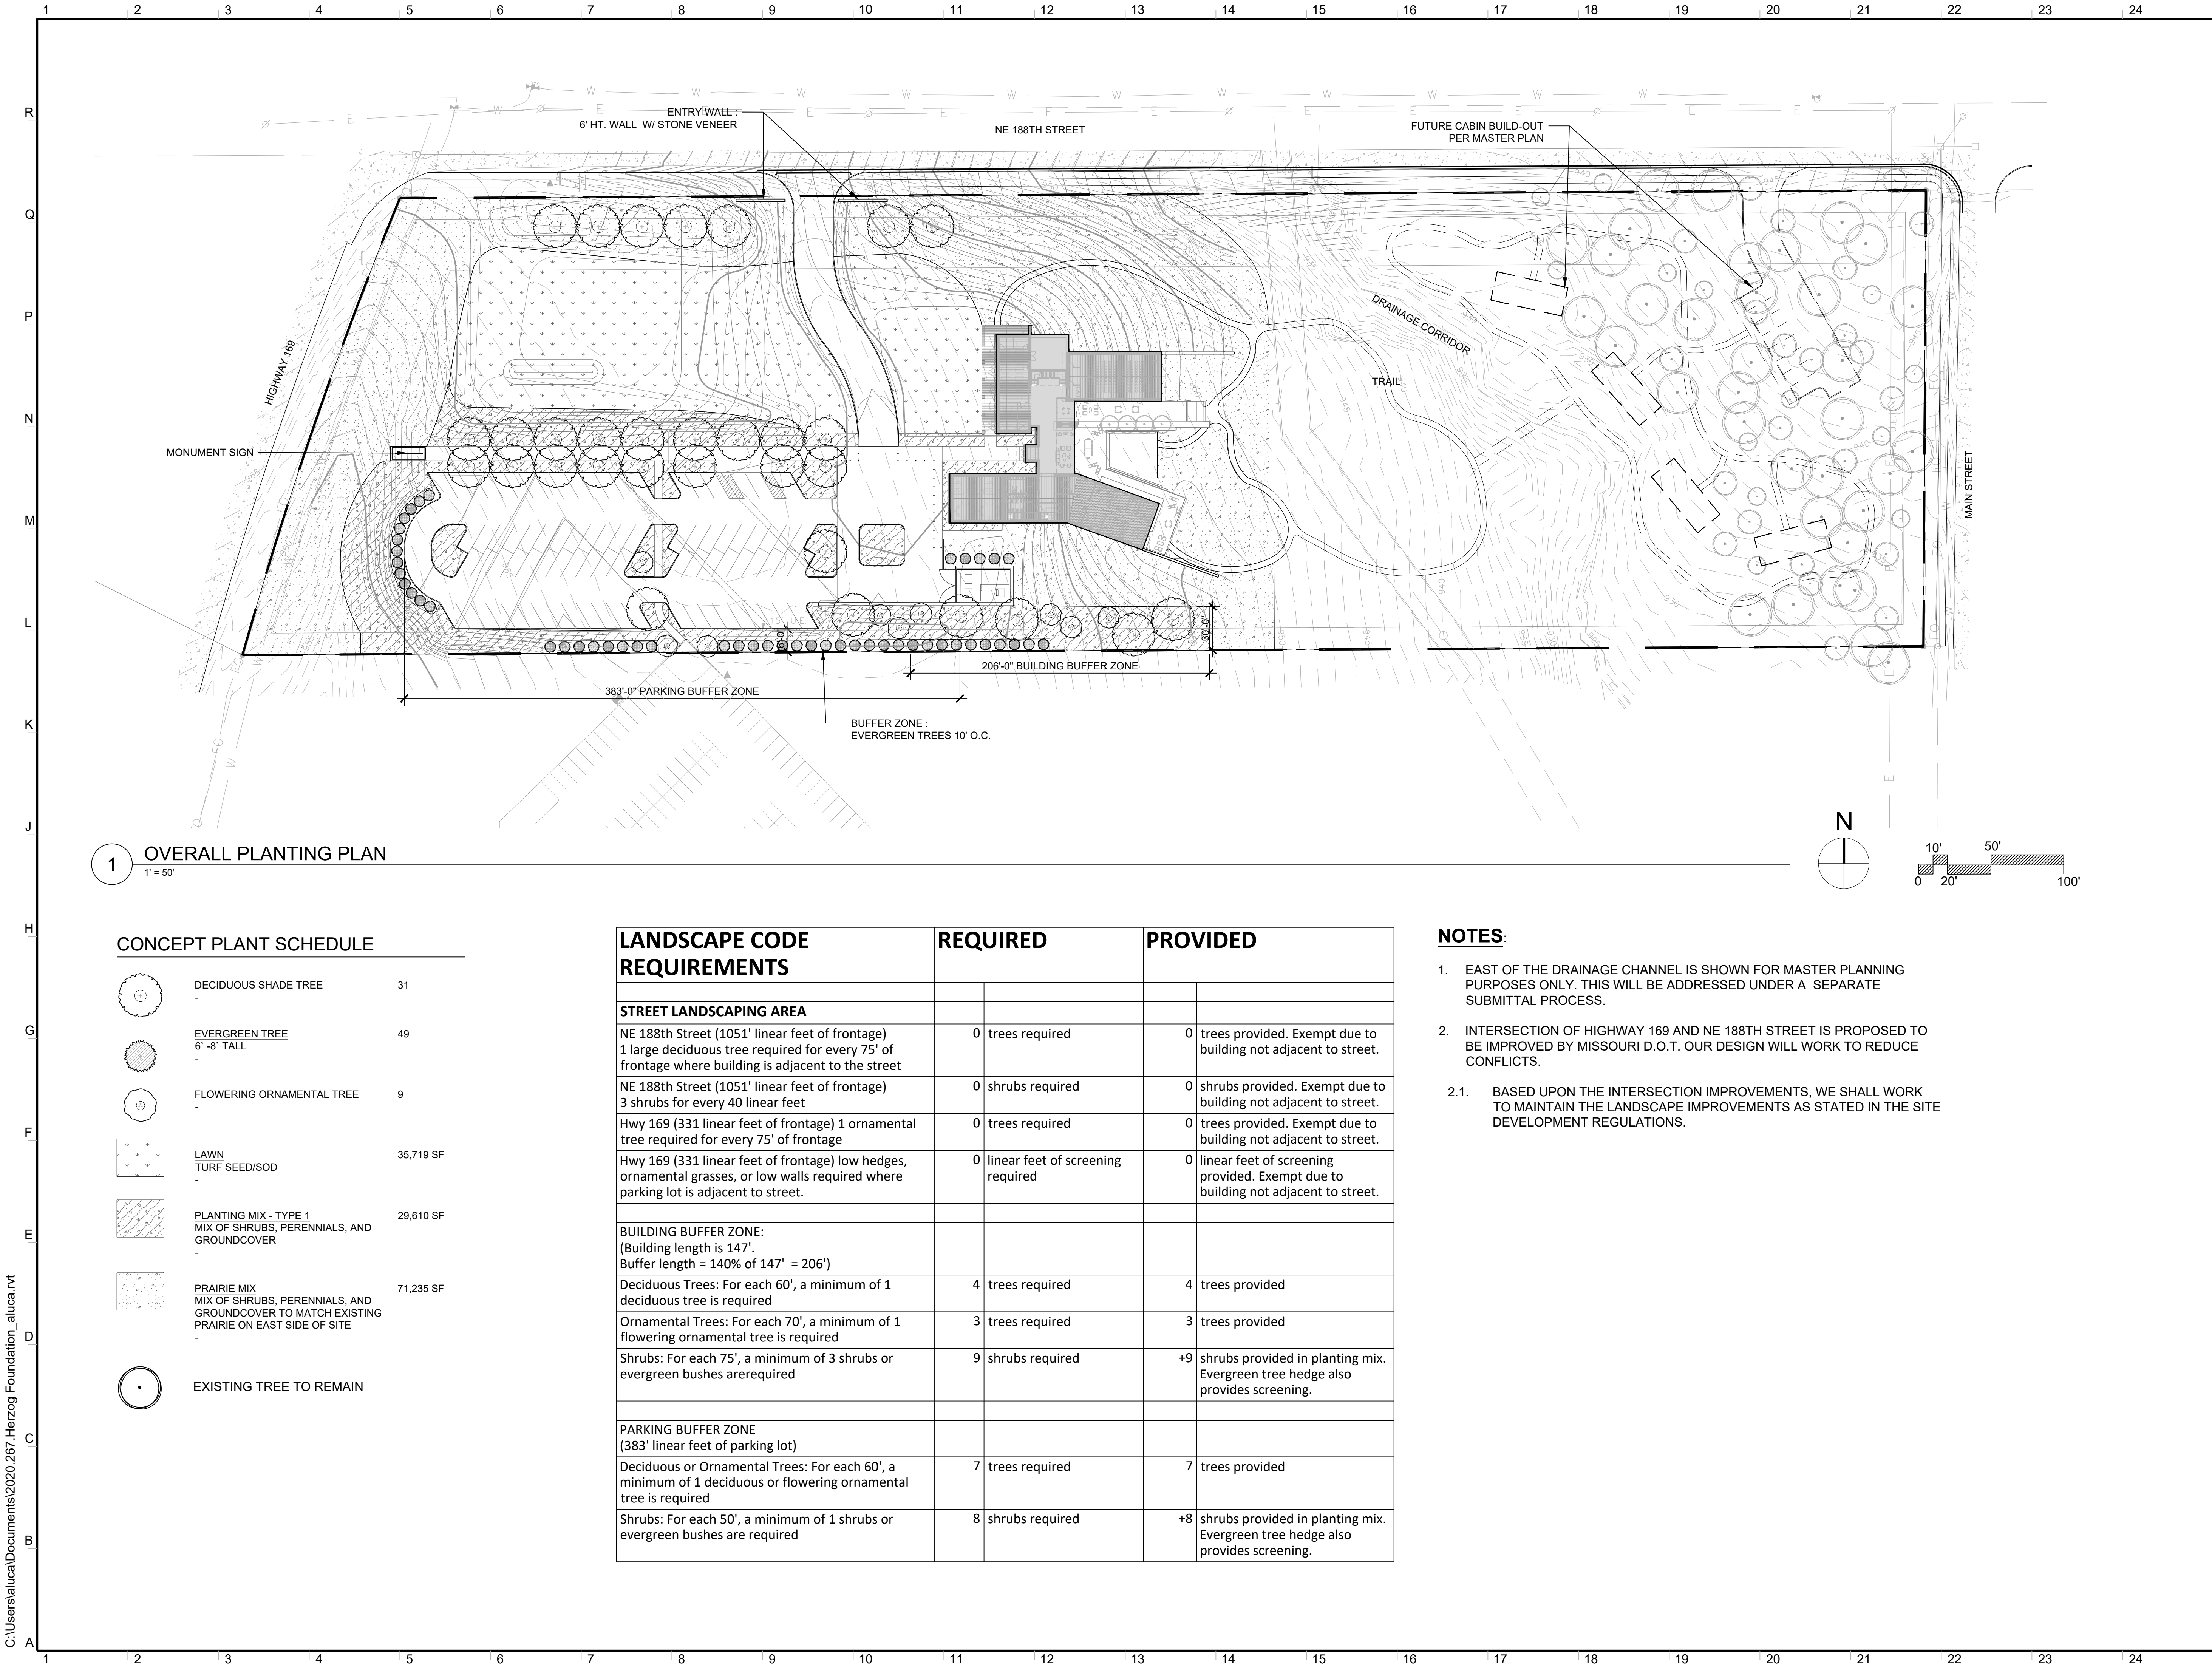

LANDSCAPE ARCHITECT
HOERR SCHAUDT LANDSCAPE ARCHITECTS
312.492.6501

CIVIL
SK Design Group, Inc.
913.451.1818

STRUCTURAL
PMA Engineering
913.831.1262

MECHANICAL, ELECTRICAL, PLUMBING
PKMR Engineers
913.492.2400

AV & ACOUSTIC
BranchPattern
913.228.3604

LIGHTING DESIGNER
LightWorks, Inc.
816.640.9948

FOOD FACILITY DESIGNER
Santee/Becker Associates, LLC
913.362.1800

Stanley Herzog
Foundation

NW 188th Street
Smithville, Missouri 64089

ISSUED FOR:
Planning Commission 08.10.2020

Drawn By
Checked By

Author
Checker

PLANTING PLAN

J:\Stanley Herzog Foundation\2020.267 Stanley Herzog Foundation\2 Drawings and Specifications\Progress Prints\2020 0810 - Planning Commission Submittal\PACKAGE 2\2020 0814 - Herzog PC2.rvt



- Keynotes:** # →
1. Precast reinforced concrete lintel
Finish: Sand texture, color to match limestone veneer
 2. Precast reinforced concrete sill
Finish: Sand texture, color to match limestone veneer
 3. 4" Limestone veneer
 4. Standing seam metal roof
Finish: Painted Zinc
 5. Aluminum Curtain Wall System.
Finish: Medium Bronze
 6. Smooth cut limestone cap
 7. Prefinished wood slat sunscreen, stain color per Arch
 8. Building mounted light fixture per lighting plan

GastingerWalker &

Architects | Interior Designers | Construction Managers
817 Wyandotte Kansas City Missouri 64105 816.421.8200 gastingerwalker.com

- LANDSCAPE ARCHITECT
HOERR SCHAUDT LANDSCAPE ARCHITECTS
312.492.6501
- CIVIL
SK Design Group, Inc
913.451.1818
- STRUCTURAL
PMA Engineering
913.631.1262
- MECHANICAL, ELECTRICAL, PLUMBING
PKMR Engineers
913.492.2400
- AV & ACOUSTIC
BranchPattern
913.228.3604
- LIGHTING DESIGNER
LightWorks, Inc.
816.640.9948
- FOOD FACILITY DESIGNER
Santee/Becker Associates, LLC
913.362.1800

Stanley Herzog Foundation

NW 188th Street
Smithville, Missouri 64089

ISSUED FOR:

Planning Commission Pkg 2 08.21.2020

Missouri Certificate of Authority: #ARC000344

Drawn By
Checked By


Author
Checker

Building Elevations

40.00


Project Number: 2020.267 © Copyright 2020

J:\Stanley Herzog Foundation\2020.267 Stanley Herzog Foundation\2 Drawings and Specifications\Progress Prints\2020 0810 - Planning Commission Submittal\PACKAGE 2\2020 0814 - Herzog PC2.rvt

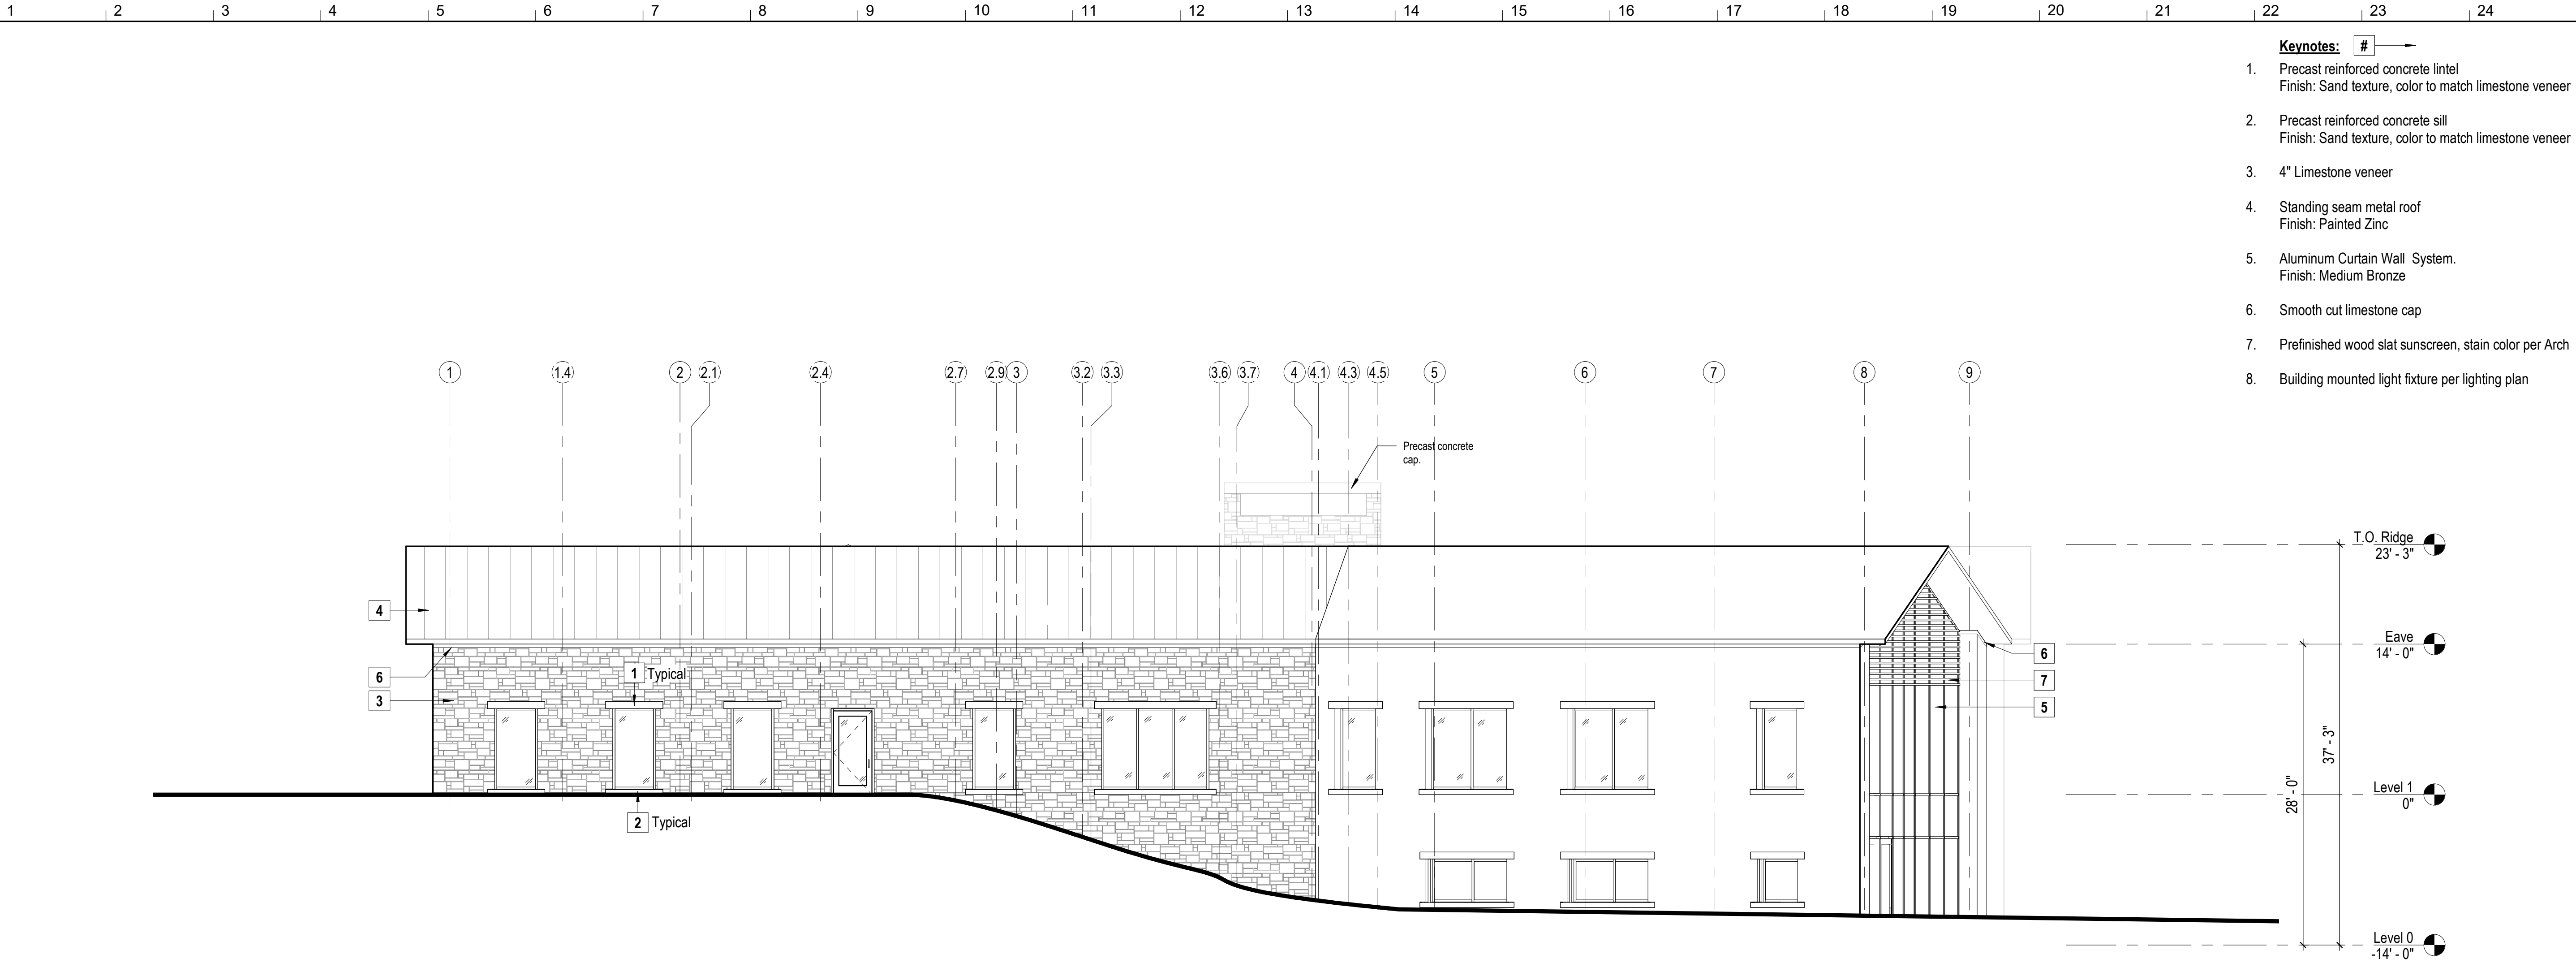

- Keynotes:** # →
1. Precast reinforced concrete lintel
Finish: Sand texture, color to match limestone veneer
 2. Precast reinforced concrete sill
Finish: Sand texture, color to match limestone veneer
 3. 4" Limestone veneer
 4. Standing seam metal roof
Finish: Painted Zinc
 5. Aluminum Curtain Wall System.
Finish: Medium Bronze
 6. Smooth cut limestone cap
 7. Prefinished wood slat sunscreen, stain color per Arch
 8. Building mounted light fixture per lighting plan

H1	Elevation at South Facade		
30.00	1/8" = 1'-0"	0	2' 4' 8'

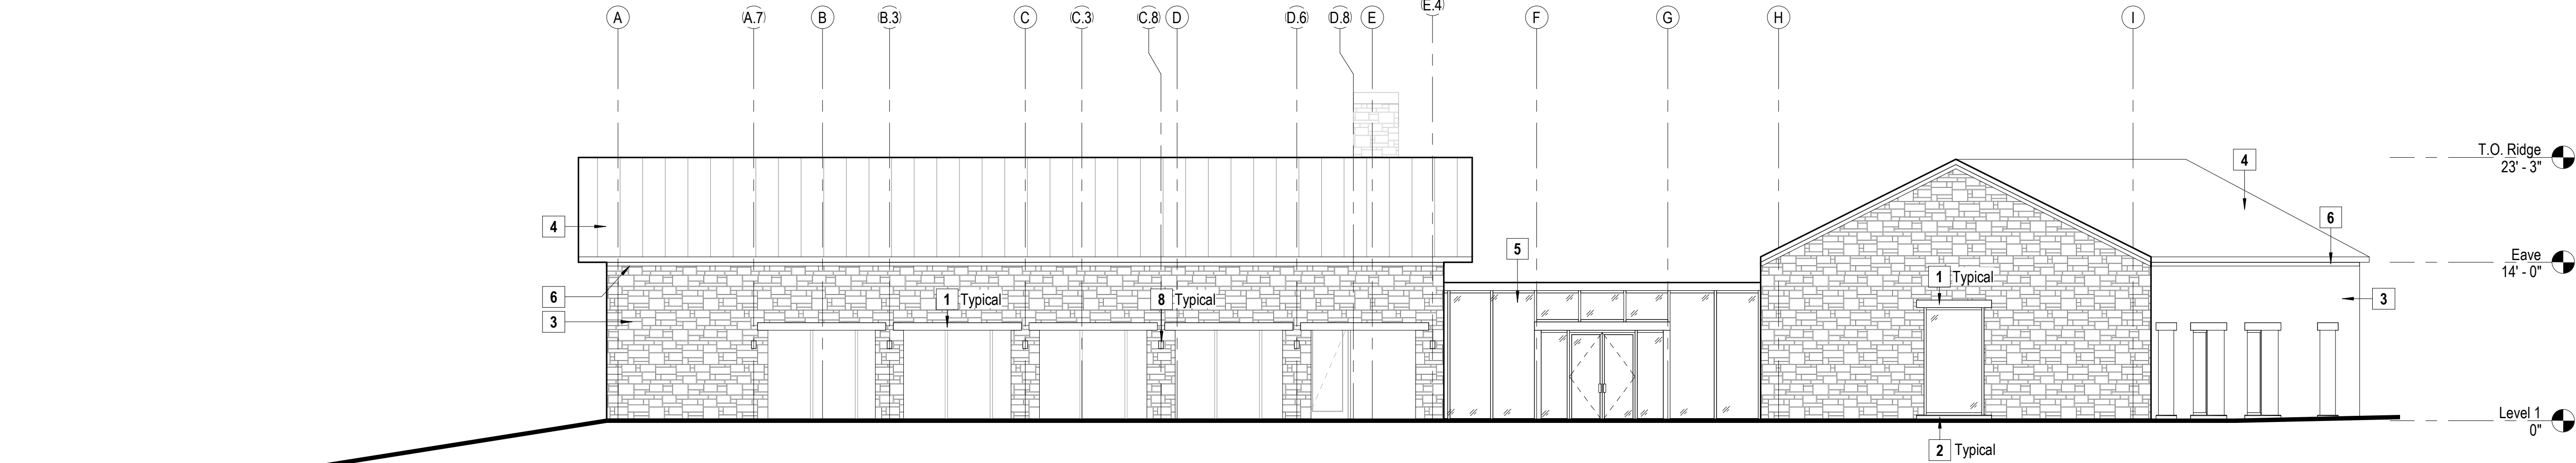

A1	Elevation at West Facade		
30.00	1/8" = 1'-0"	0	2' 4' 8'

GastingerWalker &

Architects | Interior Designers | Construction Managers
817 Wyandotte Kansas City Missouri 64105 816.421.8200 gastingerwalker.com

- LANDSCAPE ARCHITECT
HOERR SCHAUDT LANDSCAPE ARCHITECTS
312.492.6501
- CIVIL
SK Design Group, Inc
913.451.1818
- STRUCTURAL
PMA Engineering
913.631.1262
- MECHANICAL, ELECTRICAL, PLUMBING
PKMR Engineers
913.492.2400
- A/V & ACOUSTIC
Branch/Pattern
913.228.3604
- LIGHTING DESIGNER
LightWorks, Inc.
816.640.9948
- FOOD FACILITY DESIGNER
Santee/Becker Associates, LLC
913.362.1800

**Stanley Herzog
Foundation**

NW 188th Street
Smithville, Missouri 64089

ISSUED FOR:

Planning Commission Pkg 2 08.21.2020

Drawn By _____ Author
Checked By _____ Checker

Building Elevations

40.01

Project Number: 2020.267 © Copyright 2020

Architects | Interior Designers | Construction Managers
817 Wyandotte Kansas City Missouri 64105 816.421.8200 gastingerwalker.com

FOOD FACILITY DESIGNER
Santee/Becker Associates, LLC
913.362.1800

NW 188th Street
Smithville, Missouri 64089